


FLOOR PLAN

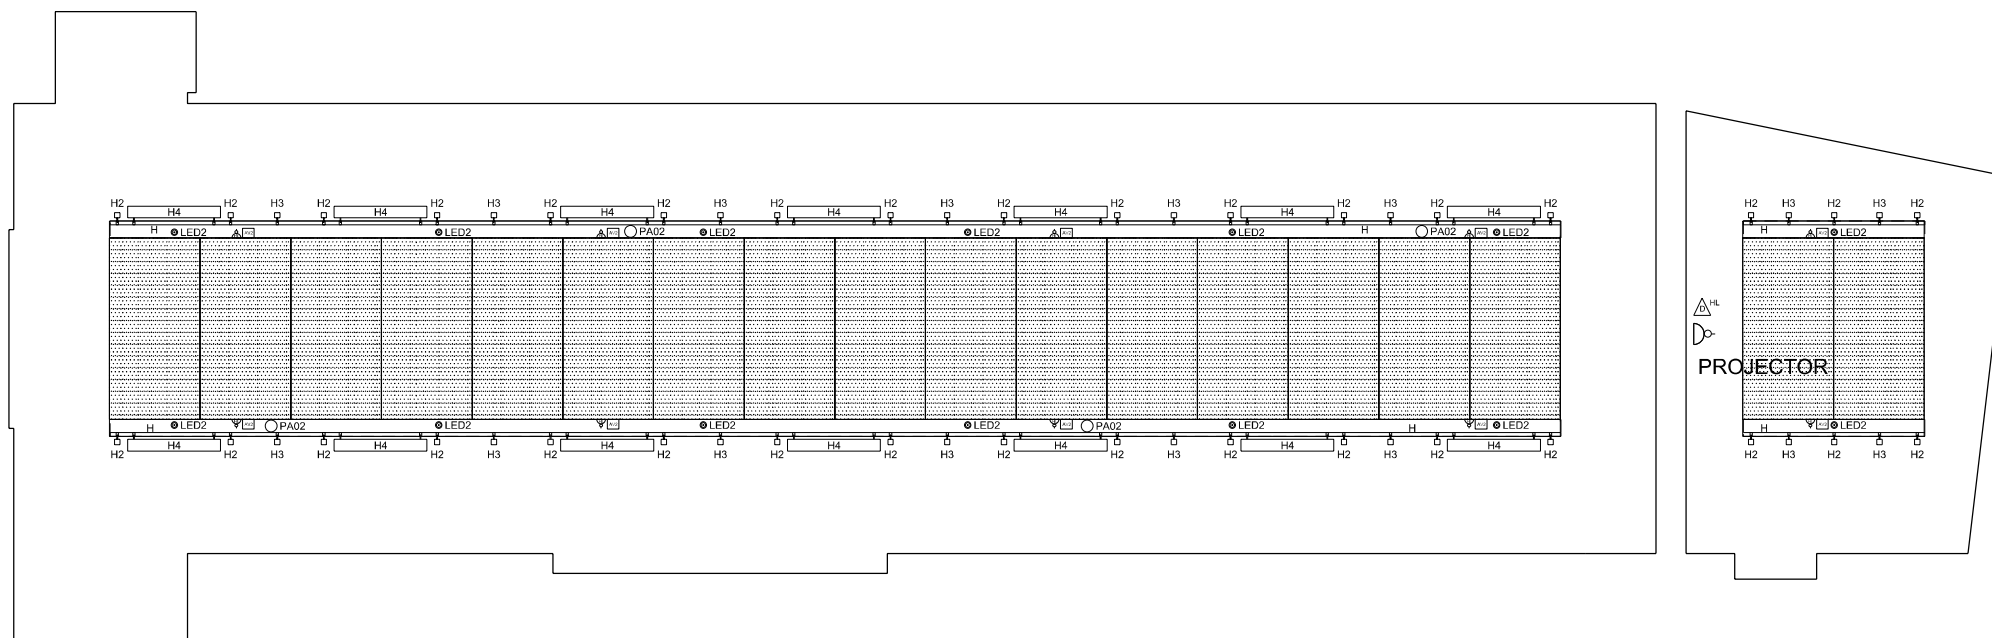

CEILING PLAN

LEGEND

- 1. WALL LINING SYSTEM TO ART GALLERY
 1no. 12.5mm GYPSUM WALLBOARDS ON
 1no. 13mm GYPSUM DURALINE BOARD ON
 12mm MDF SCREWED AT 150mm CENTRES
 TO GYPSUM METAL FRAMING. FRAMING CENTRES
 600mm
 MAX WEIGHT GALLERY DRYLINING WALL
 WILL SUPPORT 32kg/m²

NOTES:

- CEILING HEIGHT 3500mm
- CEILING LOADING NOT PERMITTED
- FLOOR ULTIMATE LOAD 10kN
- FLOOR UNIFORM DISTRIBUTION LOAD 20kN/m²
- FLOOR FIXING/SCREWING NOT PERMITTED

ELECTRICAL LEGEND

FS	FLOOR SOCKET WITH STAINLESS STEEL FLAP LID 13A 230V SINGLE OUTLET
FB3	ELECTRICAL FLOOR BOX IN RAISED ACCESS FLOOR 2no TWIN POWER SOCKETS 2no DATA OUTLET 1no AV OUTLET (HDMI, VGA & 3.5mm AUDIO JACK)
SSP2	GALLERY SCENE SET DIMMING PANEL
[Symbol]	WARM AIR SUPPLY FLOOR TRENCH WITH HARDWOOD GRILLE
[Symbol]	TWIN POWER POINT ON WALL AT LOW LEVEL
[Symbol]	ICT DATA POWER POINT ON WALL AT LOW LEVEL
[Symbol]	LIGHT SWITCH
[Symbol]	BLIND SWITCH
[Symbol]	PROJECTOR POWER SOURCE & DATA

REV	REVISION TITLE	DATE

Dun Laoghaire Central Library and Cultural Centre

FLOOR & CEILING PLANS OF ART GALLERY SPACE

CARR COTTER & NAESSENS ARCHITECTS

Project No. 08DLR
 Drawing No. 08DLR_SK_3288
 Scale 1:100
 Sheet size A3
 Date March 2015

32 South Terrace
 Cork
 T: 021 4847123
 F: 021 4847896
 info@ccnarchitects.net
 www.ccnarchitects.net

© Copyright
 This drawing and any design hereon is the copyright of the architects and must not be reproduced without their consent. Drawings remain the property of the architects. Do not scale off drawings. Use written dimensions.