


© COPYRIGHT OF THIS DRAWING IS RESERVED BY DBFL CONSULTING ENGINEERS. NO PART SHALL BE REPRODUCED OR TRANSMITTED WITHOUT THEIR WRITTEN PERMISSION.

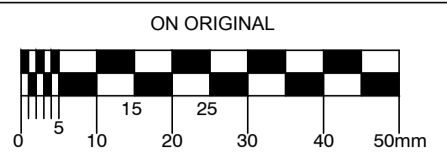

- NOTES:
- WX00 WATERCOURSE CROSSING
 - WATERCOURSE (EPA MAPPED)
 - WATERCOURSE (LOCAL DRAINAGE)
 - SW01 SURFACE WATER MONITORING POINT

- Notes
- DRAWINGS ARE PRELIMINARY DESIGNS FOR PLANNING ONLY AND ARE SUBJECT TO DETAILED DESIGN
 - ALL WATERCOURSE CROSSING WORKS SUBJECT TO OPIW SECTION 50 APPROVAL AND APPROVAL BY INLAND FISHERIES IRELAND

GOLF STREAM

GLENAMUCK STREAM

LOUGHLINSTOWN RIVER

P1	13-03-19	ISSUED FOR PLANNING	DJC	JPC
REV.	DATE	DESCRIPTION	BY	CHKD
DRAWING SUITABILITY		S2 - FOR INFORMATION		
PLANNING				
DESIGNED	JPC	PREPARED	DJC	
DATE	JAN 2019	CHECKED	BLJK	

DUBLIN OFFICE: Ormond House, Upper Ormond Quay, Dublin 7, Ireland. PHONE: +353 1 403 4000 FAX: +353 1 400 4050

WATERFORD OFFICE: Unit 2, The Chandlery, 1-2 O'Connell Street, Waterford, Ireland. PHONE: +353 51 309 500 FAX: +353 51 844 913

DBFL Consulting Engineers email: info@dbfl.ie www: www.dbfl.ie

PROJECT
GLENAMUCK DISTRICT ROADS SCHEME



DRG. TITLE
FIGURE 14-1 - HYDROLOGICAL SETTING




SCALE 1:5000 @A1 FILE REF. 170172-DBFL-01-XX-DR-C-3100
 1:10000 @A3

DBFL DRG. NO. 170172-DBFL-01-XX-DR-C-3100 P1

EIAR FIGURE REF **FIGURE 14-1**


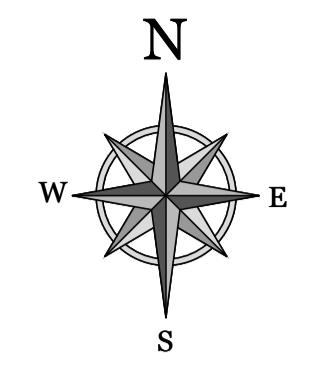
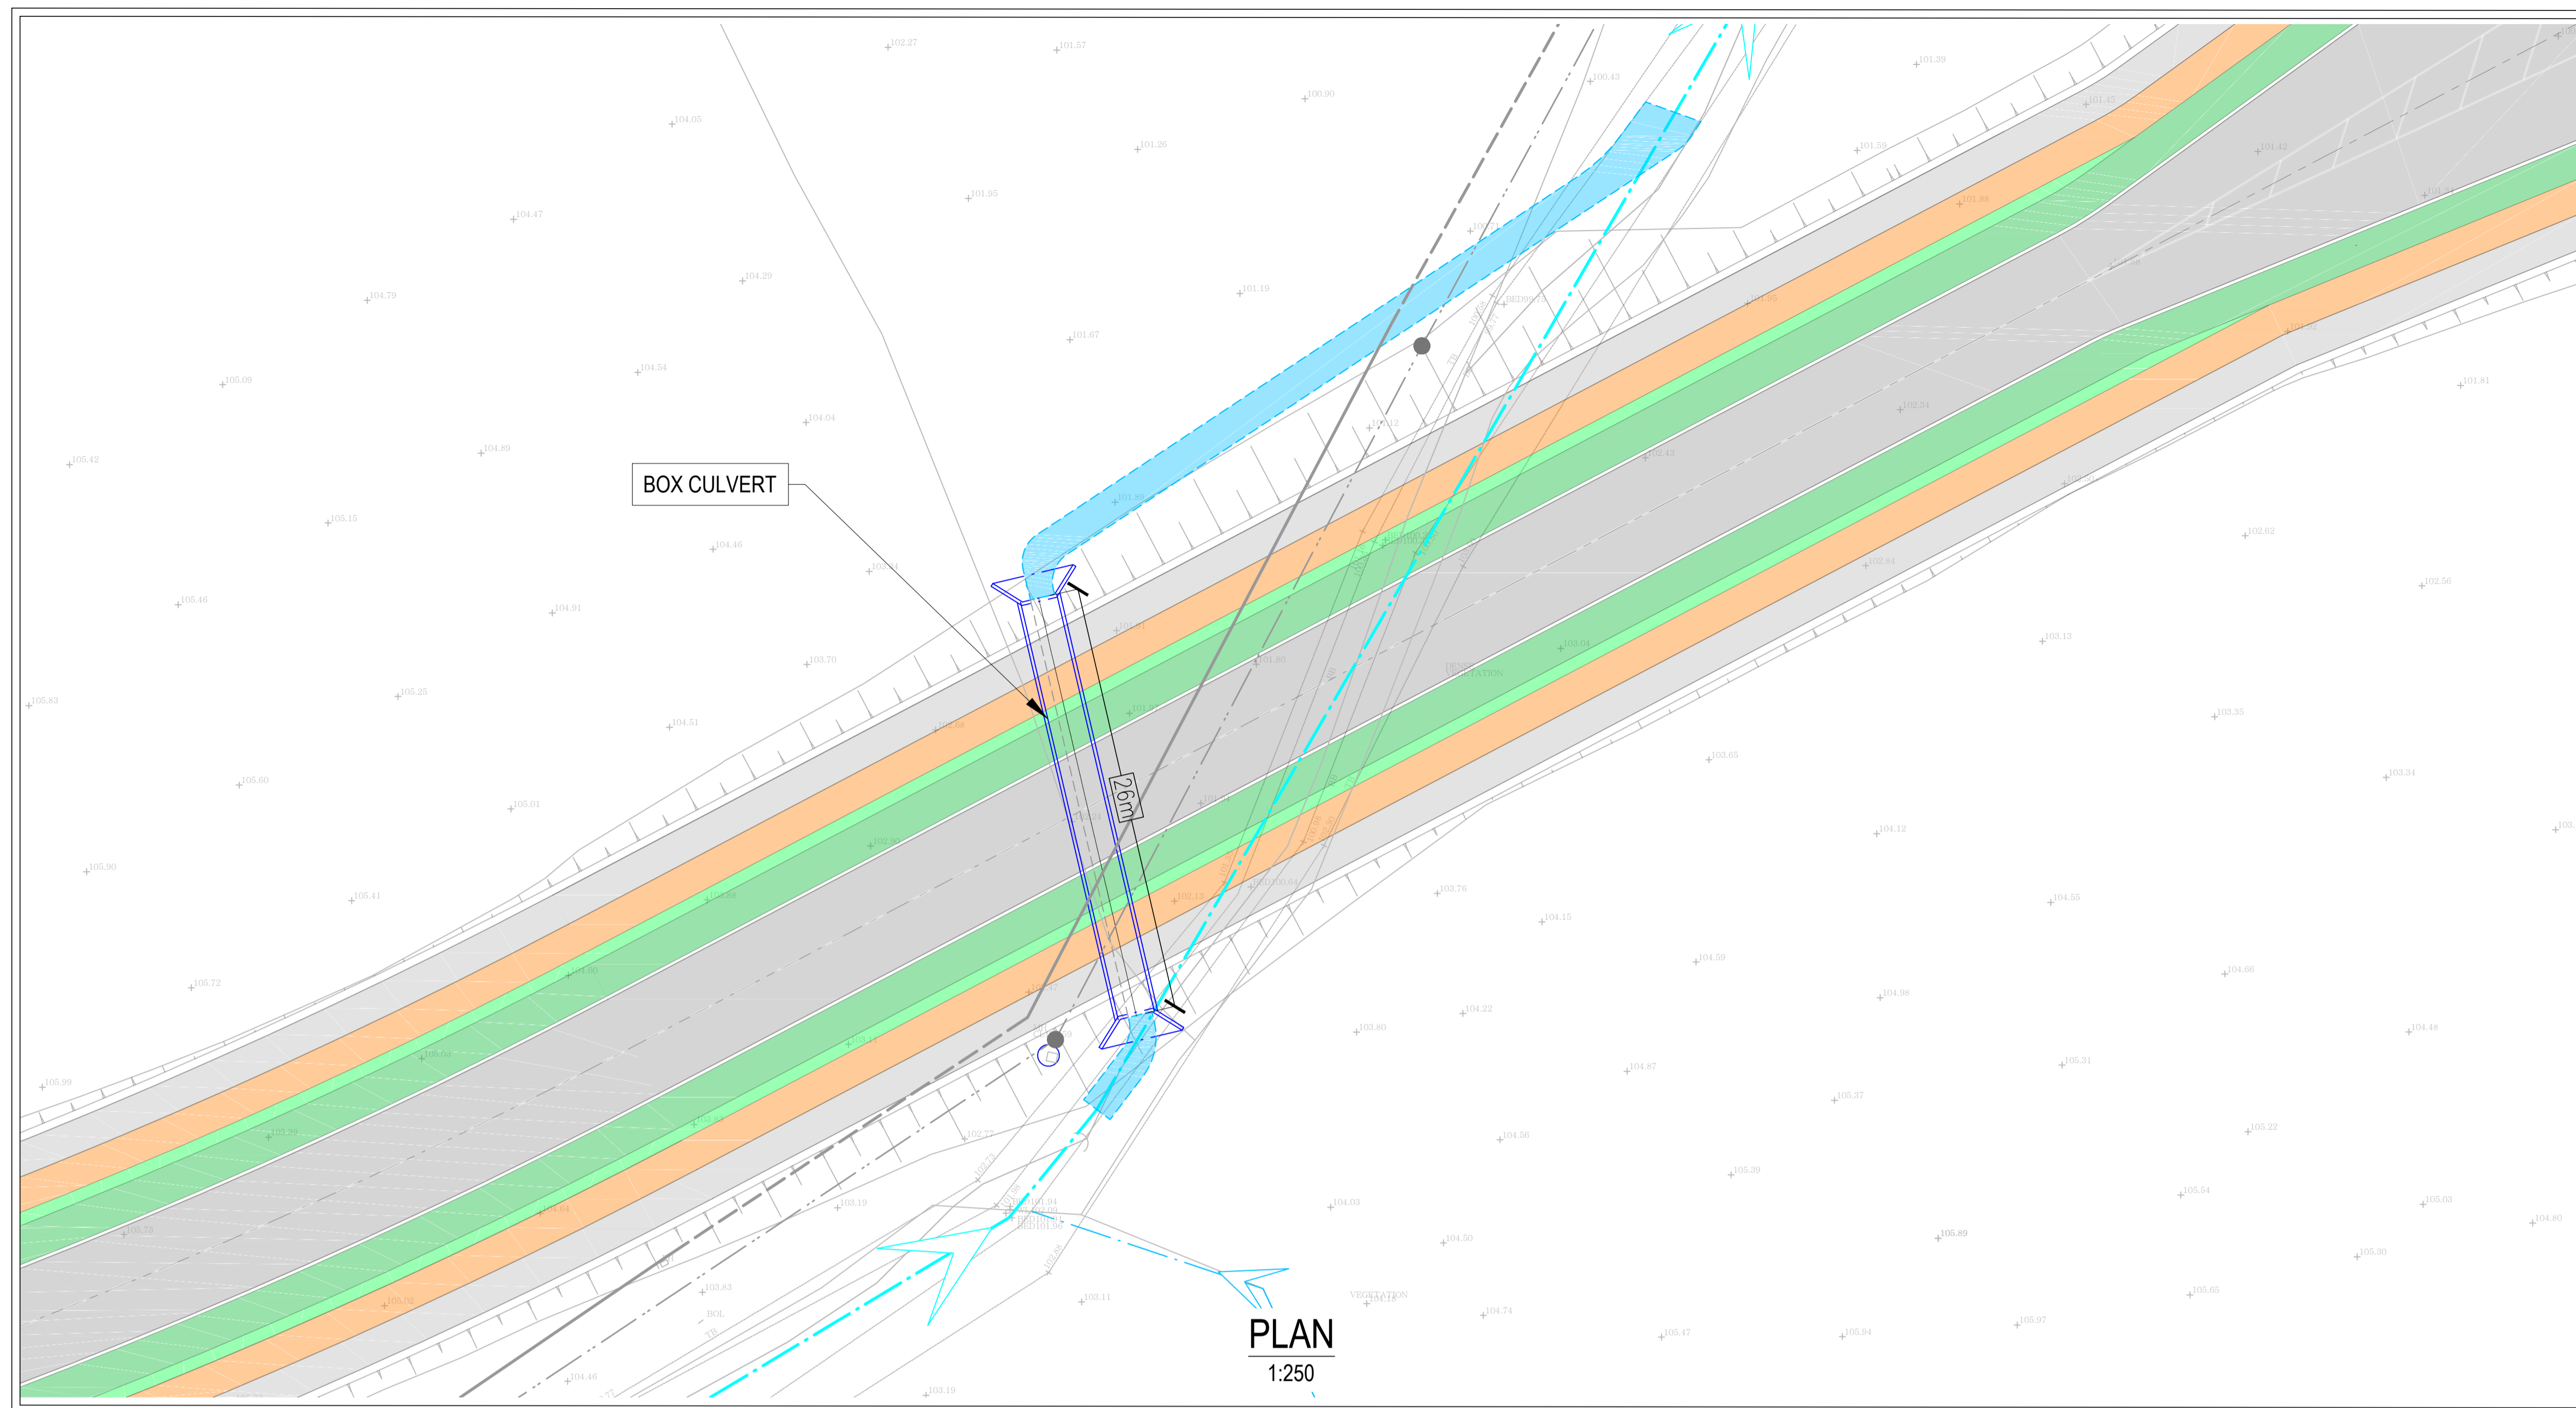


© COPYRIGHT OF THIS DRAWING IS RESERVED BY DBFL CONSULTING ENGINEERS. NO PART SHALL BE REPRODUCED OR TRANSMITTED WITHOUT THEIR WRITTEN PERMISSION.

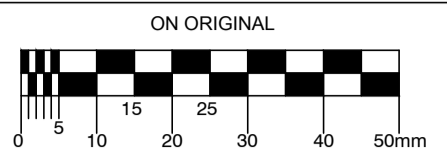

- NOTES:
1. DRAWINGS ARE PRELIMINARY DESIGNS FOR PLANNING ONLY AND ARE SUBJECT TO DETAILED DESIGN
 2. ALL WATERCOURSE CROSSING WORKS SUBJECT TO OPW SECTION 50 APPROVAL AND APPROVAL BY INLAND FISHERIES IRELAND

- LEGEND
- WX00 → WATERCOURSE CROSSING
 - WATERCOURSE (EPA MAPPED)
 - WATERCOURSE (LOCAL DRAINAGE)

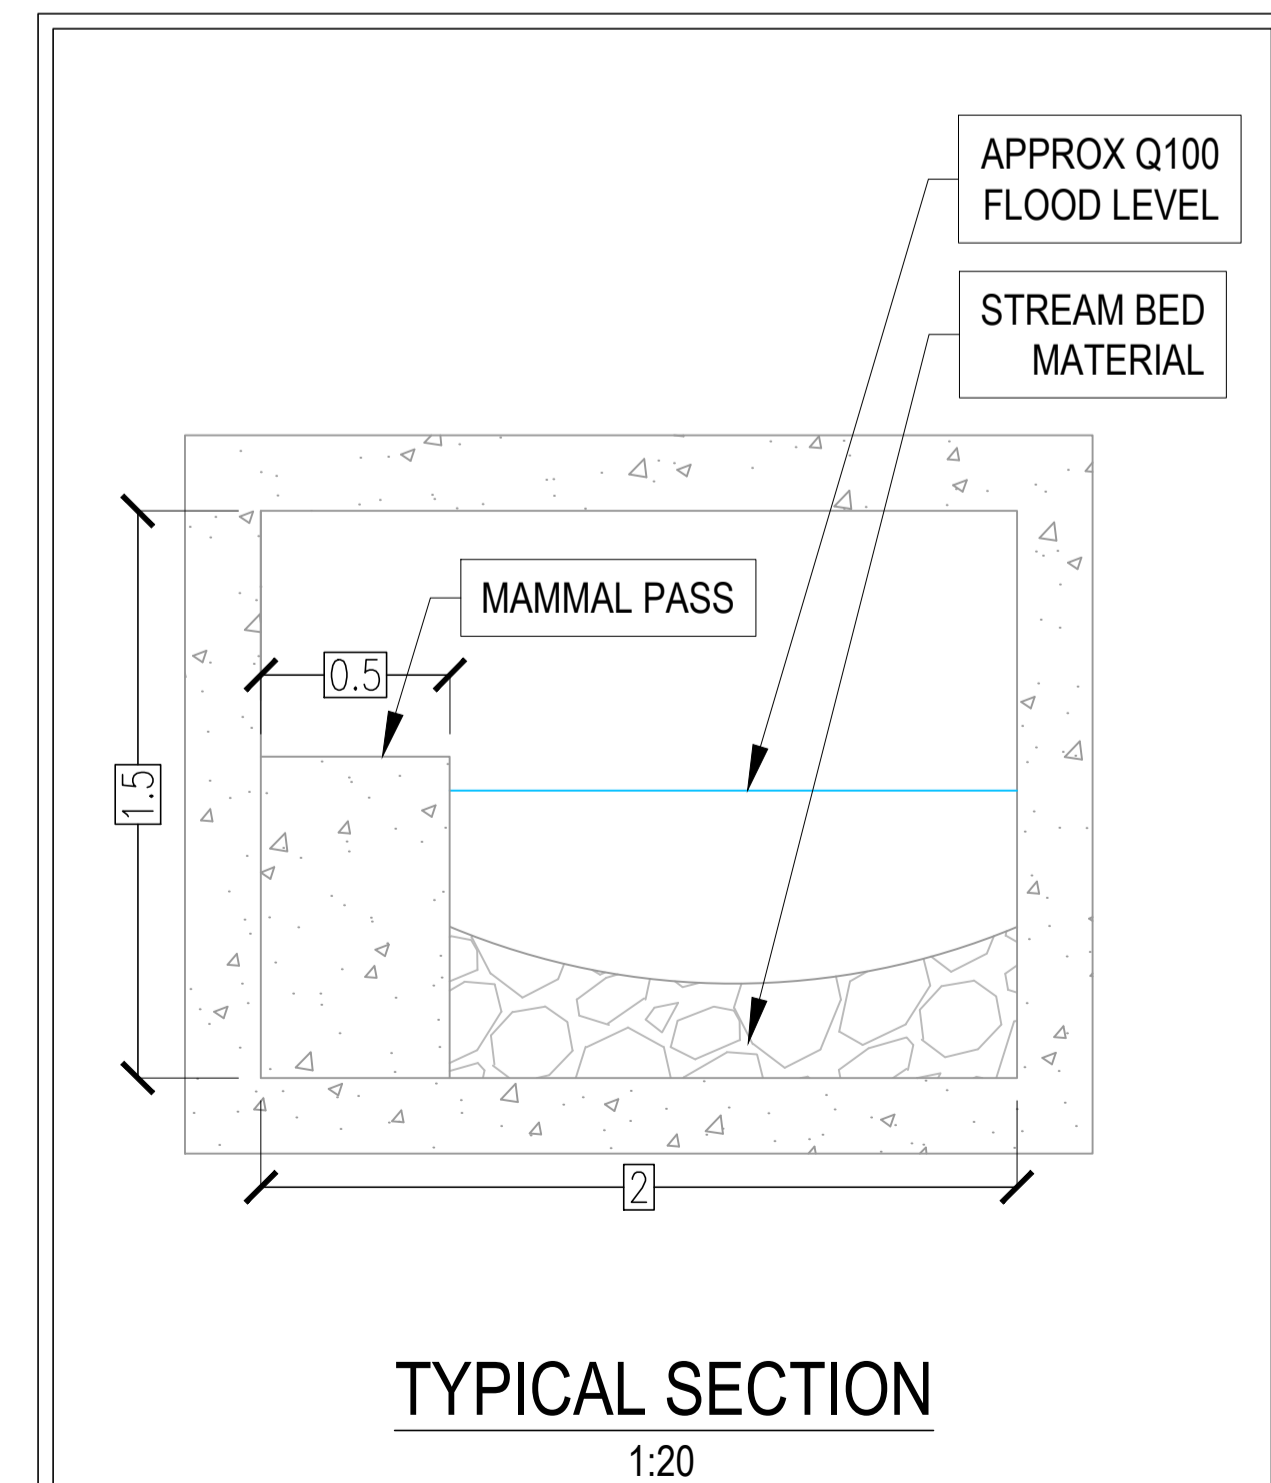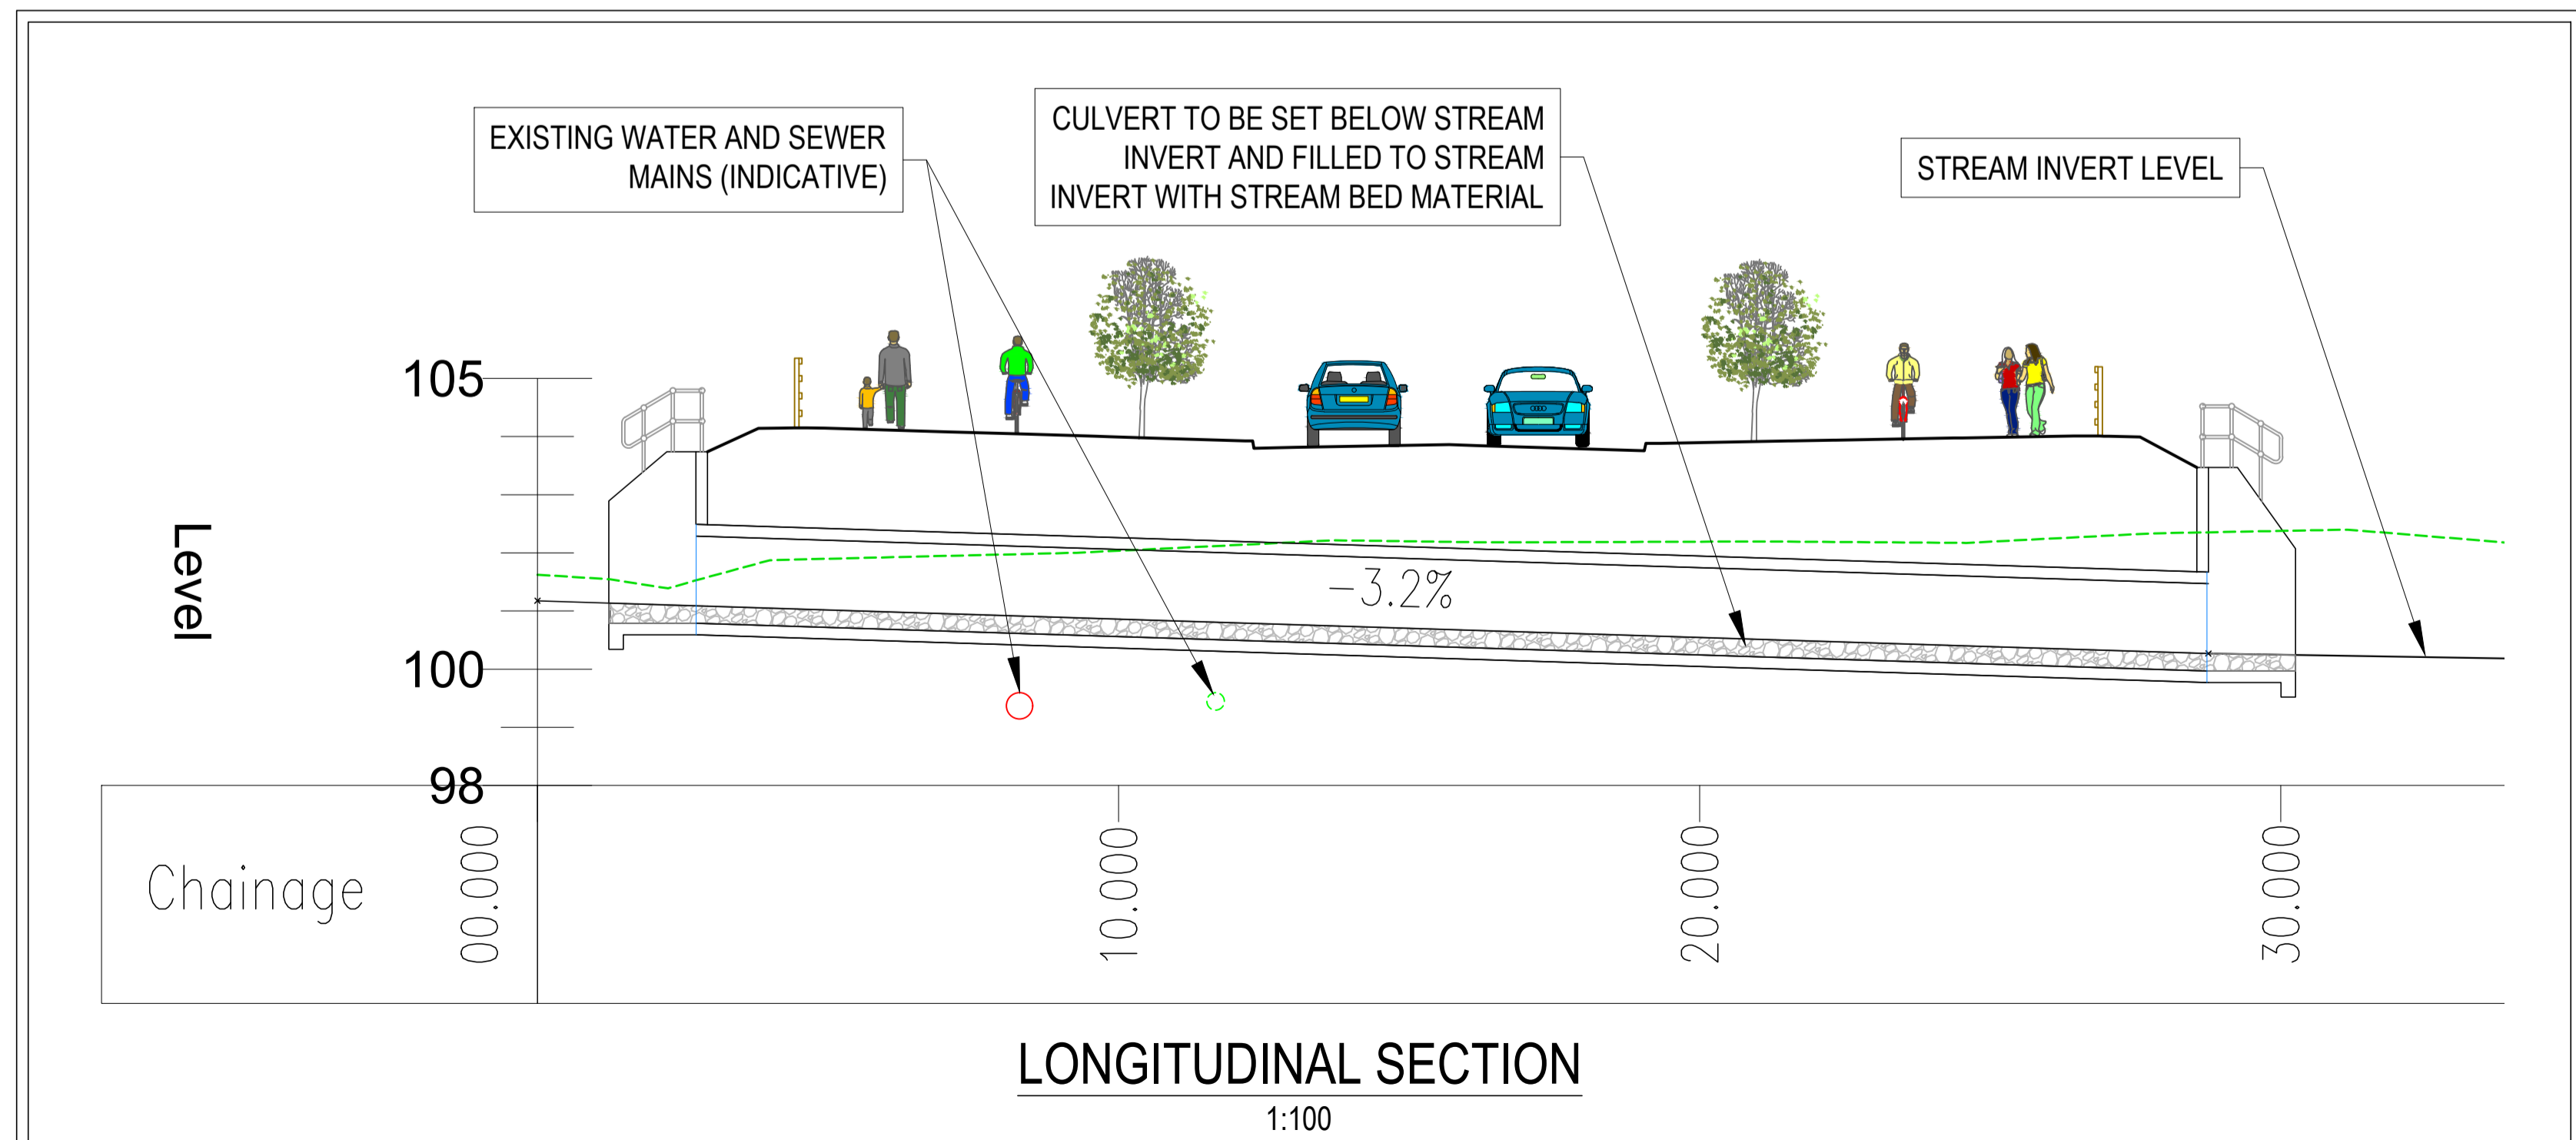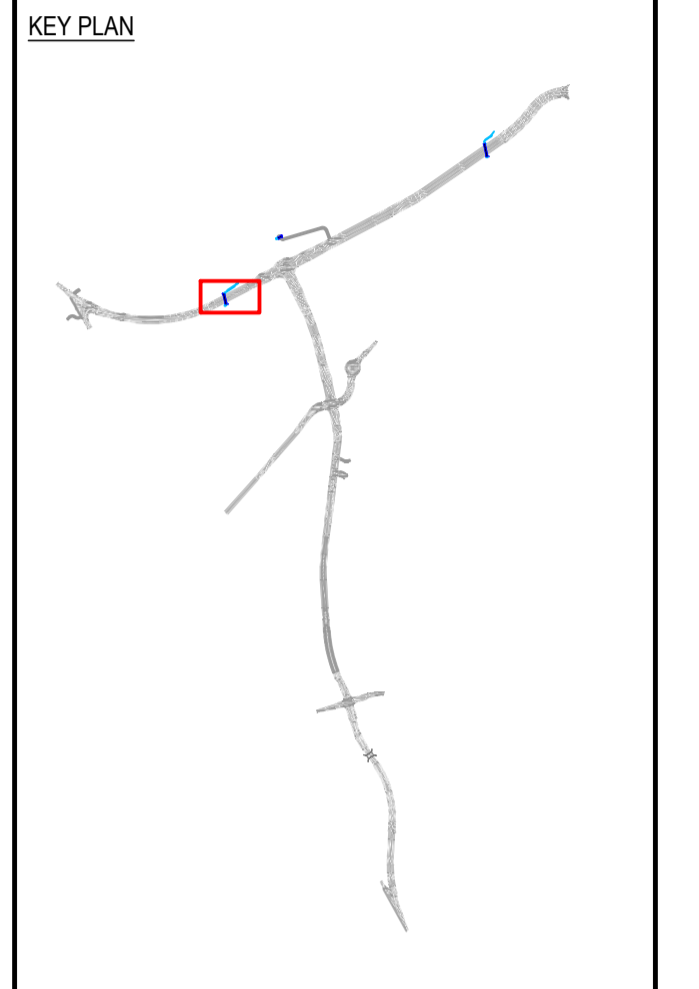

REV.	DATE	DESCRIPTION	BY	CHKD.
P1	13-03-19	ISSUED FOR PLANNING	DJG	JPC

PLANNING			
DESIGNED	JPC	PREPARED	DJG
DATE	JAN 2019	CHECKED	BLJK
DUBLIN OFFICE Ormond House, Upper Ormond Quay, Dublin 7, Ireland. PHONE +353 1 400 4000 FAX +353 1 400 4050 WATERFORD OFFICE Unit 2, The Chandlers, 1-2 O'Connell Street, Waterford, Ireland. PHONE +353 51 309 500 FAX +353 51 844 913 DBFL Consulting Engineers email: info@dbfl.ie site: www.dbfl.ie			

PROJECT
GLENAMUCK DISTRICT ROADS SCHEME


DRG. TITLE
FIGURE 14-2 - WATERCROSSING DETAILS - WX01




SCALE AS SHOWN @A1 FILE REF. 170172-DBFL-01-XX-DR-C-3101
 AS SHOWN X2 @A3

DBFL DRG. NO. 170172-DBFL-01-XX-DR-C-3101 P1

EIA REFERENCE FIGURE 14-2


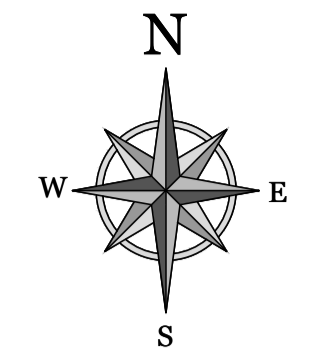


© COPYRIGHT OF THIS DRAWING IS RESERVED BY DBFL CONSULTING ENGINEERS. NO PART SHALL BE REPRODUCED OR TRANSMITTED WITHOUT THEIR WRITTEN PERMISSION.

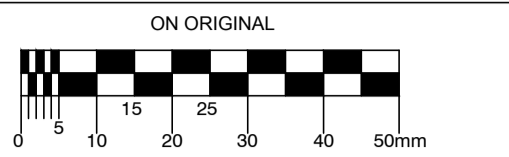


- NOTES:
1. DRAWINGS ARE PRELIMINARY DESIGNS FOR PLANNING ONLY AND ARE SUBJECT TO DETAILED DESIGN
 2. ALL WATERCOURSE CROSSING WORKS SUBJECT TO OPW SECTION 50 APPROVAL AND APPROVAL BY INLAND FISHERIES IRELAND


- LEGEND
- WX00 WATERCOURSE CROSSING
 - WATERCOURSE (EPA MAPPED)
 - WATERCOURSE (LOCAL DRAINAGE)

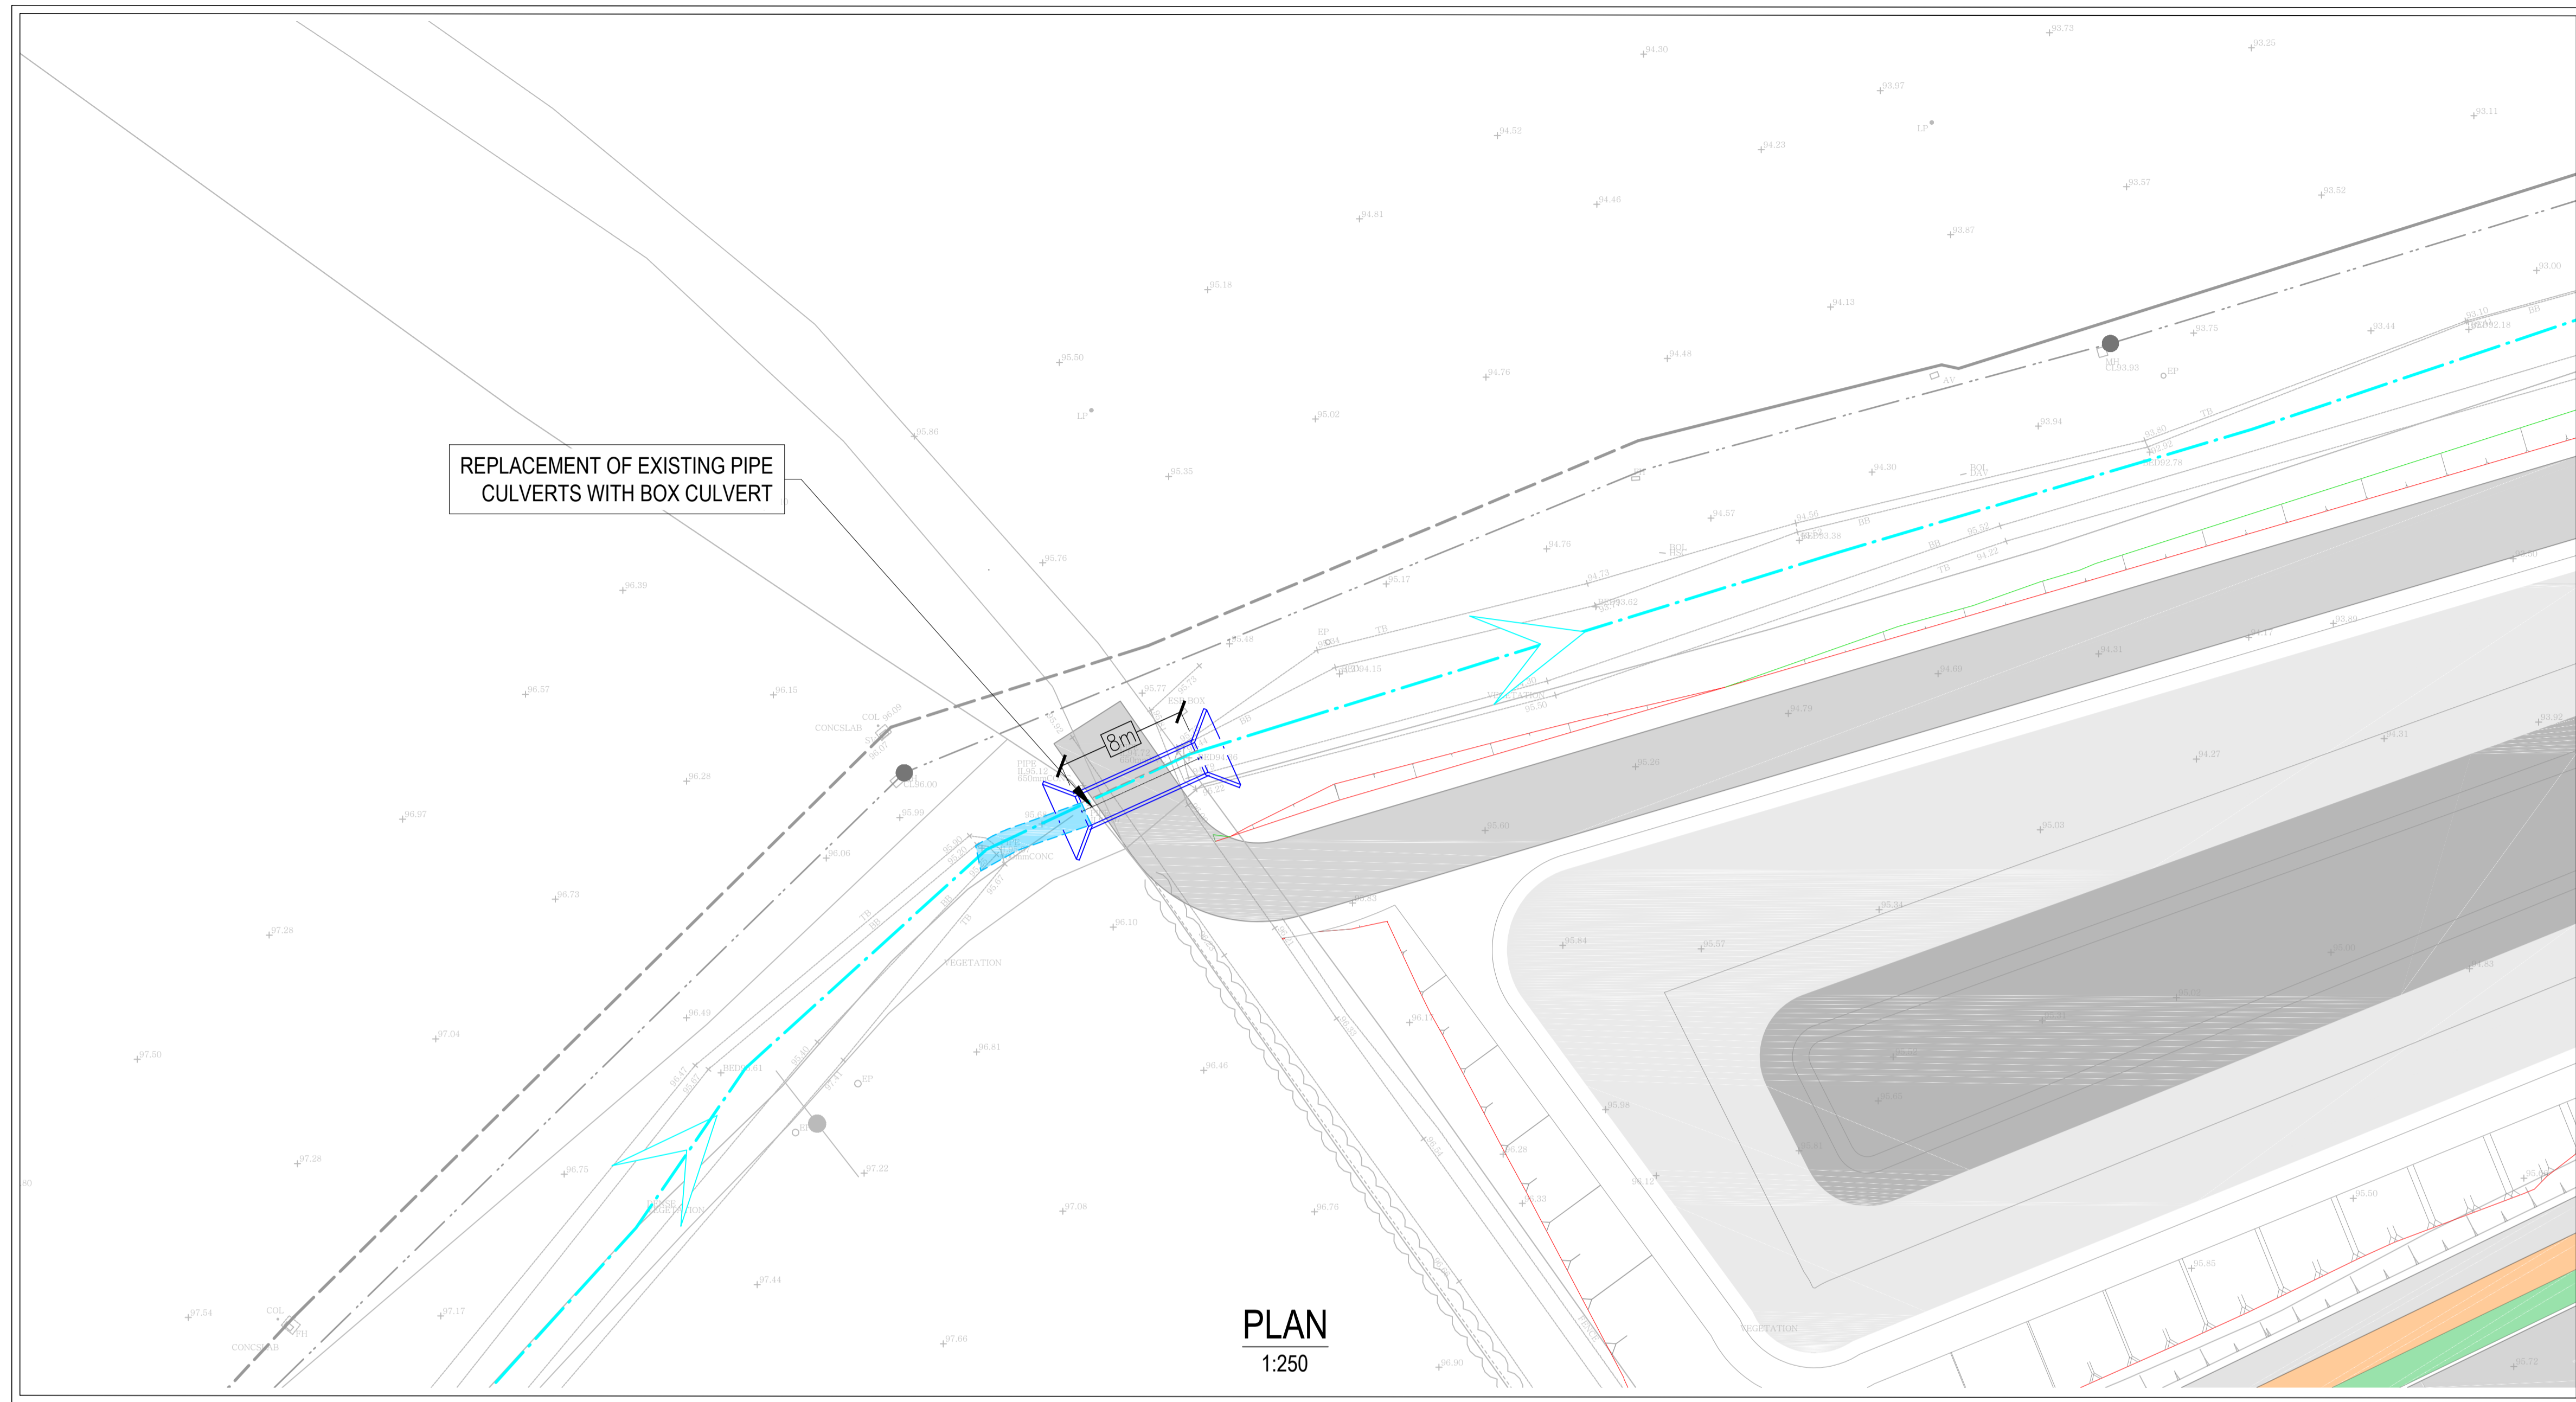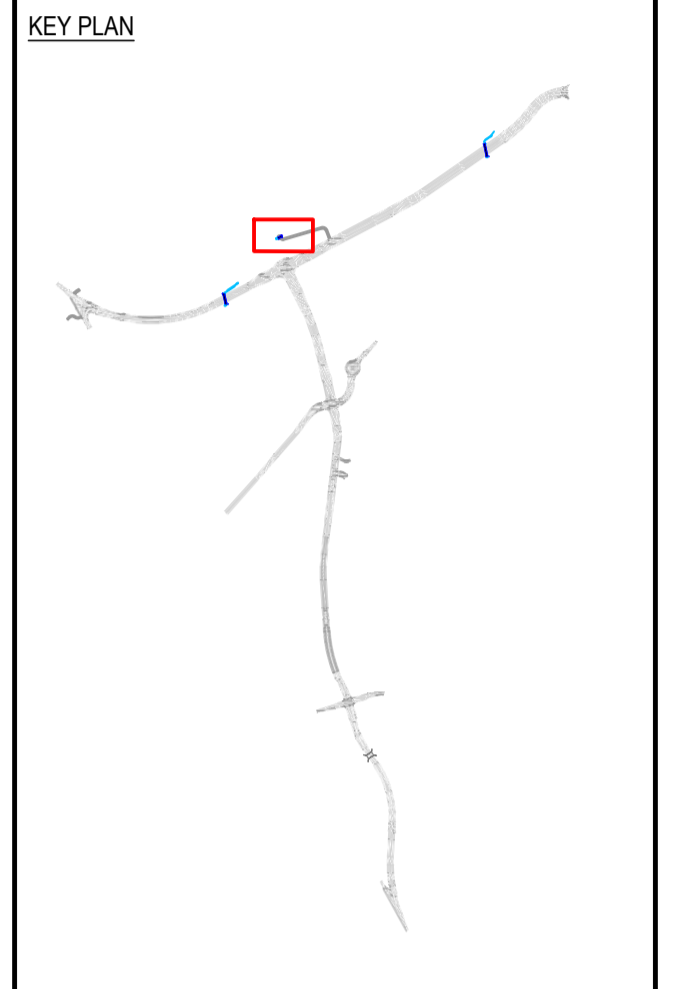

PLAN
1:250

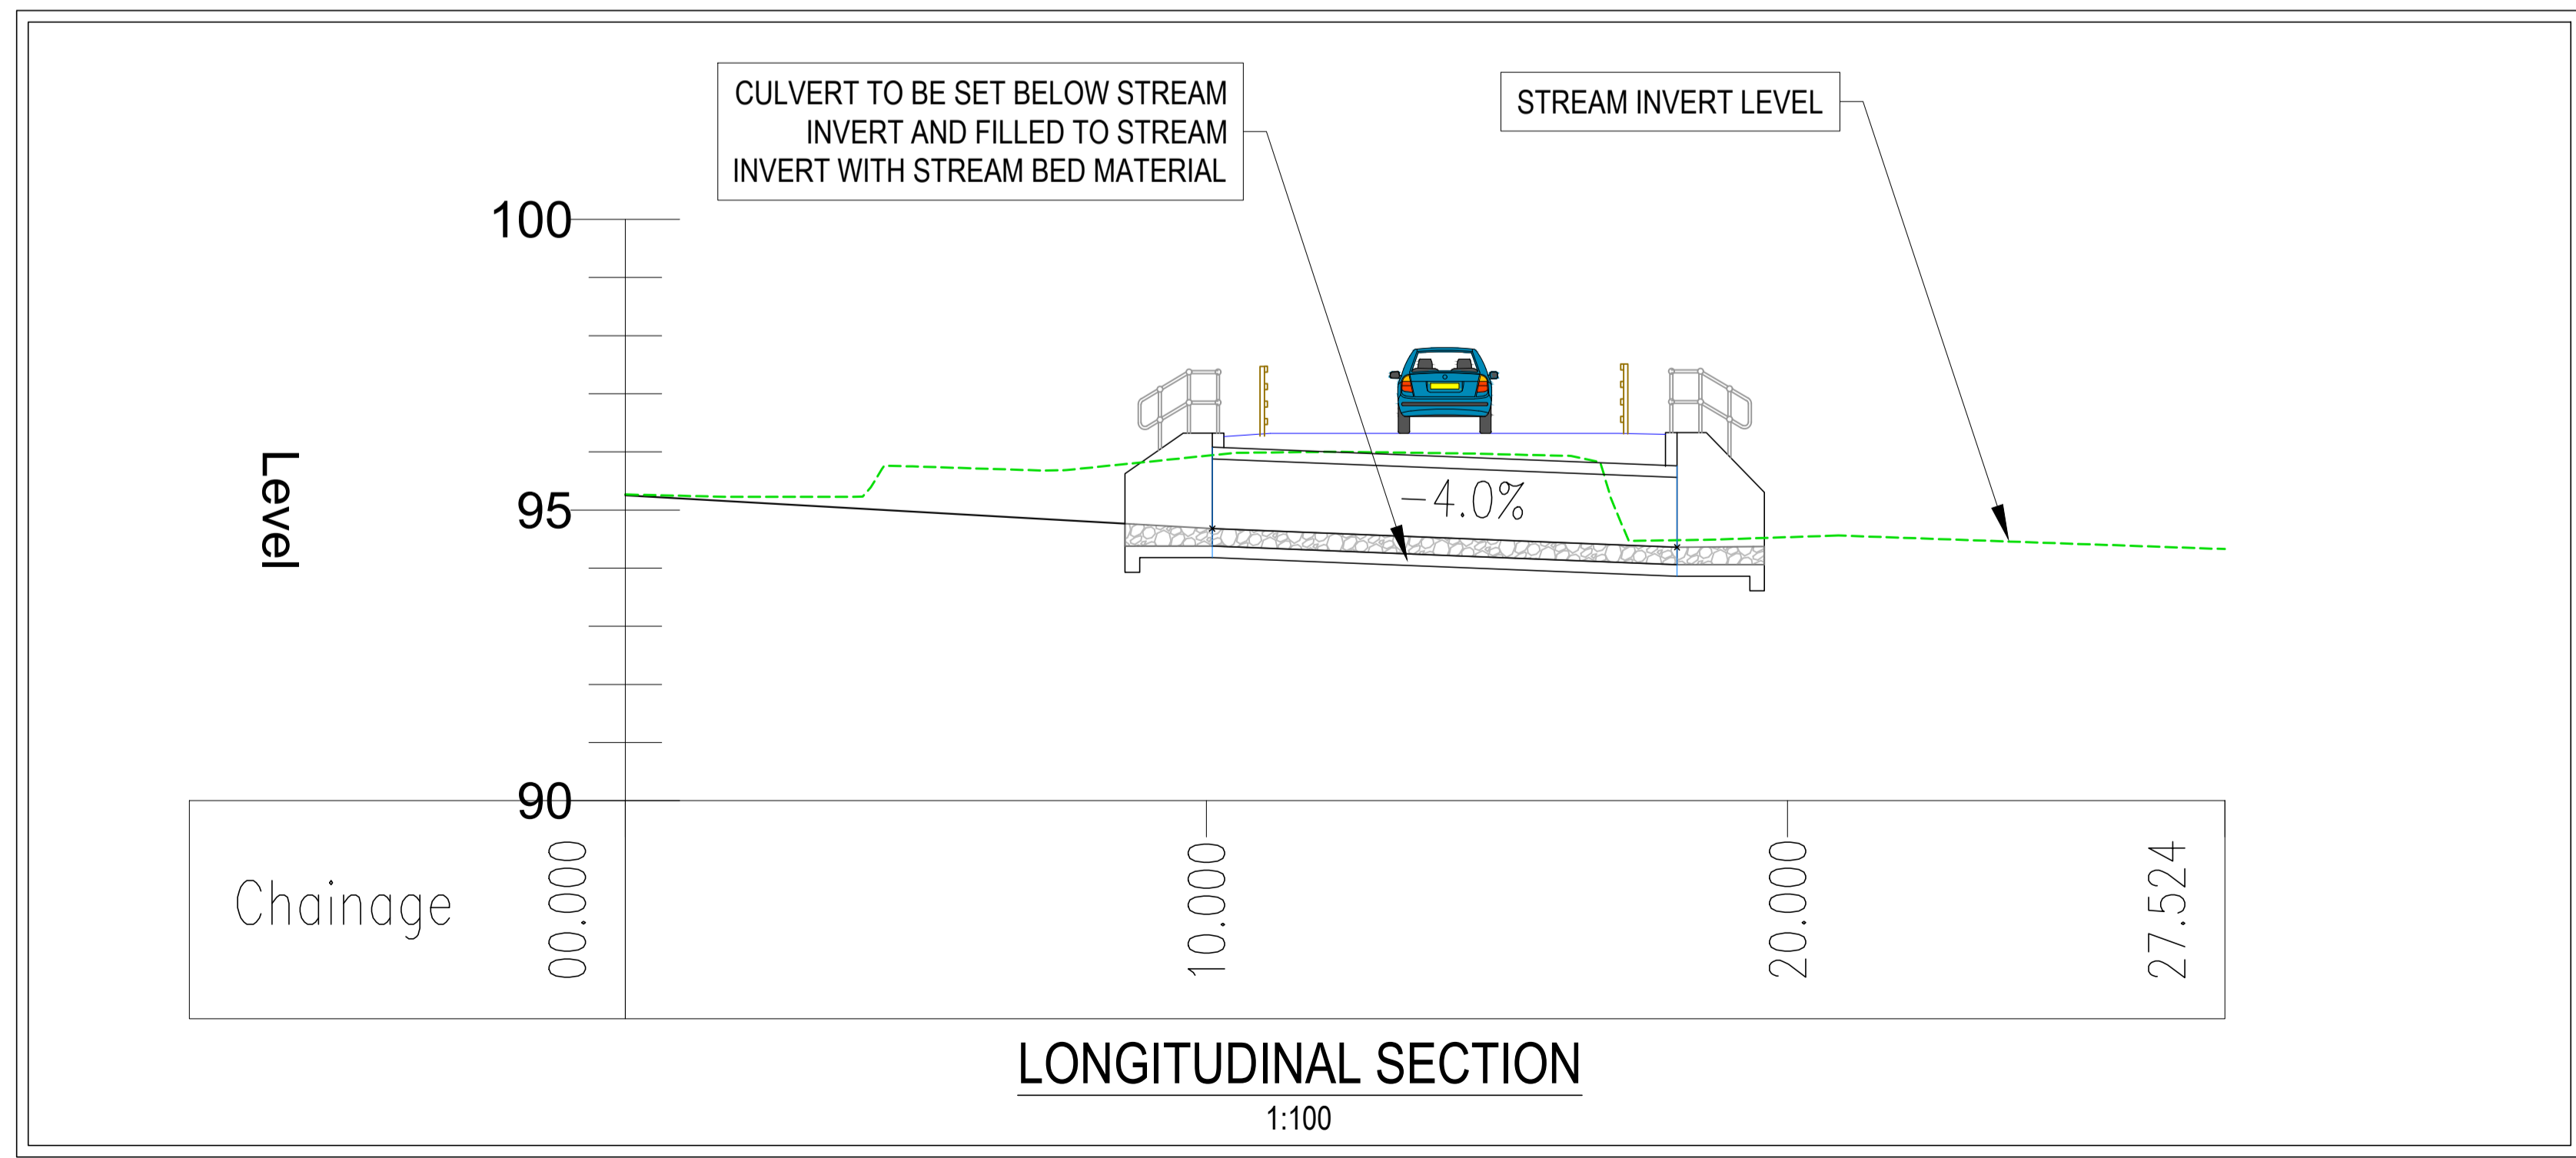

LONGITUDINAL SECTION
1:100

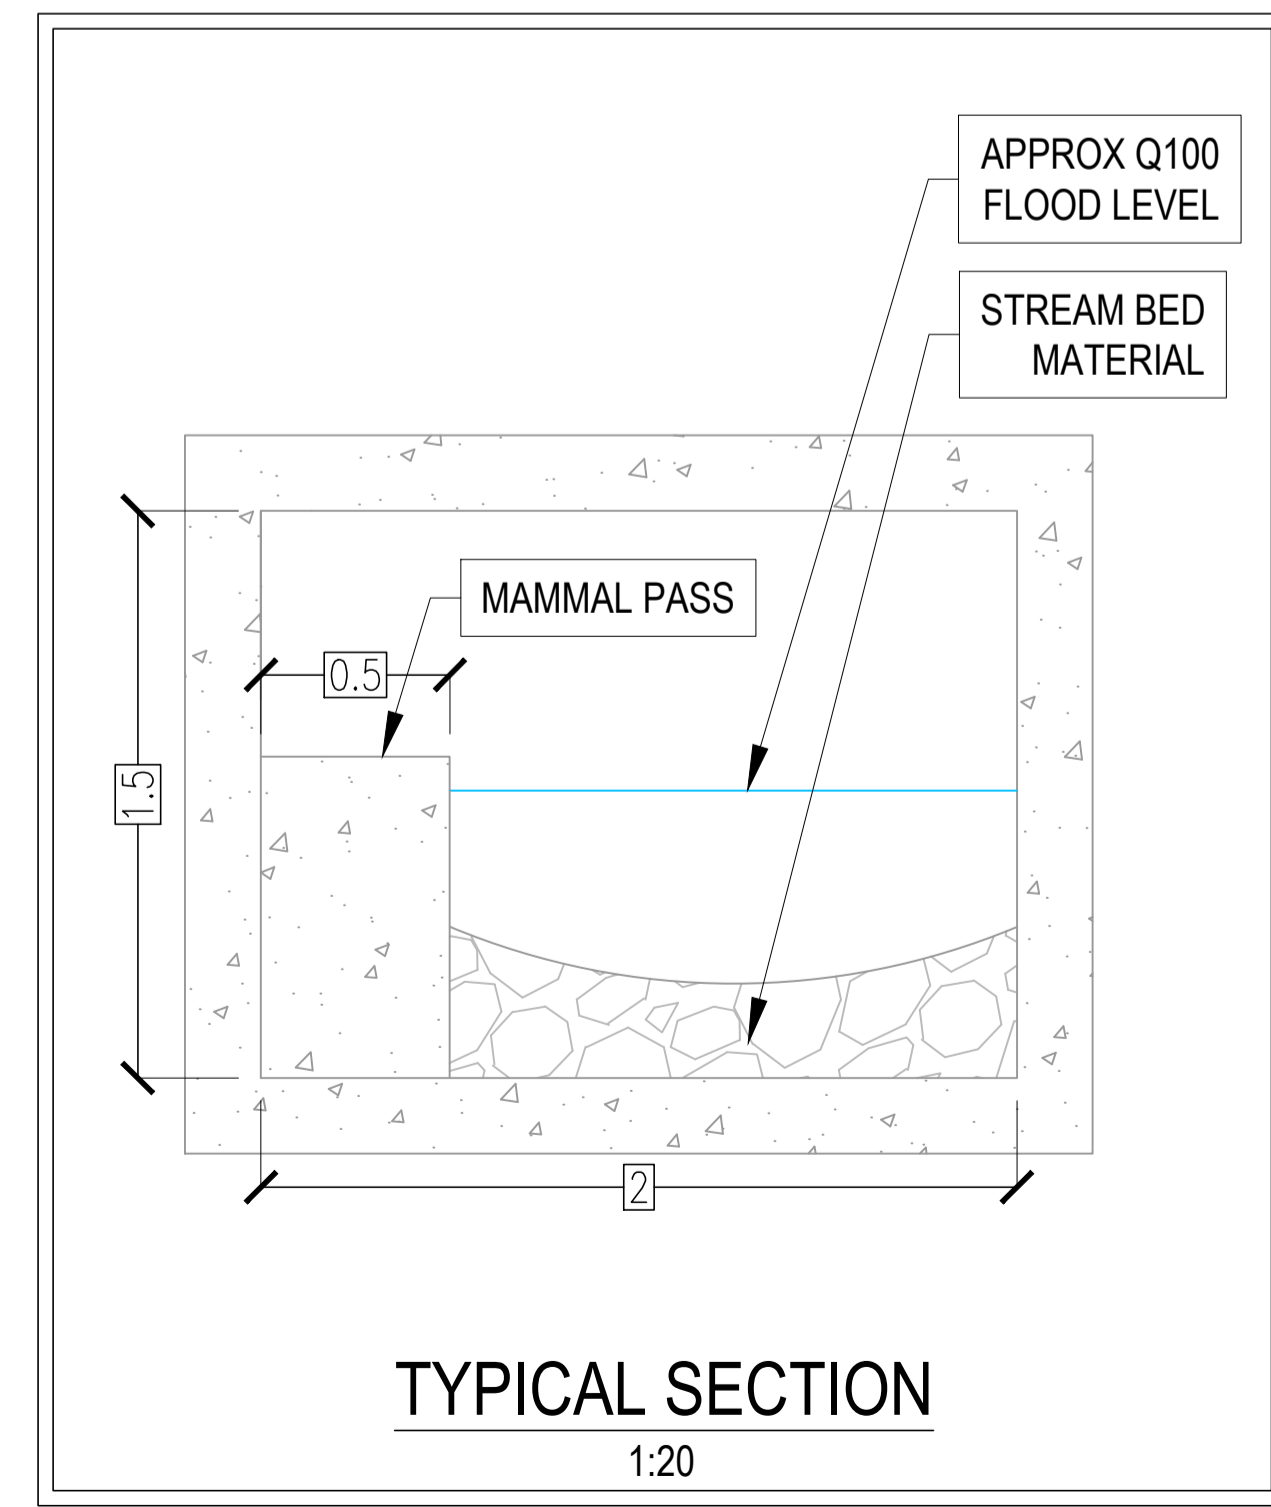

TYPICAL SECTION
1:20

P1	13-03-19	ISSUED FOR PLANNING	DJC	JPC
REV.	DATE	DESCRIPTION	BY	CHKD
DRAWING SUITABILITY		S2 - FOR INFORMATION		
PLANNING				
DESIGNED	JPC	PREPARED	DJC	
DATE	JAN 2019	CHECKED	BLK	

DBFL
DUBLIN OFFICE Ormond House,
Upper Ormond Quay, Dublin 7, Ireland.
PHONE +353 1 400 4000
FAX +353 1 400 4050

WATERFORD OFFICE Unit 2, The Chandlery,
1-2 O'Connell Street, Waterford, Ireland.
PHONE +353 51 309 500
FAX +353 51 844 913

DBFL Consulting Engineers email: info@dbfl.ie www: www.dbfl.ie

PROJECT
GLENAMUCK DISTRICT ROADS SCHEME


DRG. TITLE
FIGURE 14-3 - WATERCROSSING DETAILS - WX02




SCALE AS SHOWN @A1 AS SHOWN X2 @A3 FILE REF. 170172-DBFL-01-XX-DR-C-3101

DBFL DRG. NO. 170172-DBFL-01-XX-DR-C-3102 P1

EIAR FIGURE REF **FIGURE 14-3**

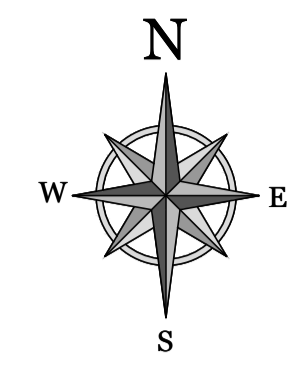


© COPYRIGHT OF THIS DRAWING IS RESERVED BY DBFL CONSULTING ENGINEERS. NO PART SHALL BE REPRODUCED OR TRANSMITTED WITHOUT THEIR WRITTEN PERMISSION.


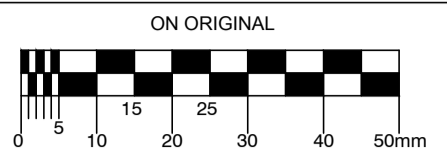


- NOTES:
1. DRAWINGS ARE PRELIMINARY DESIGNS FOR PLANNING ONLY AND ARE SUBJECT TO DETAILED DESIGN
 2. ALL WATERCOURSE CROSSING WORKS SUBJECT TO OPW SECTION 50 APPROVAL AND APPROVAL BY INLAND FISHERIES IRELAND

- LEGEND
- WX00 WATERCOURSE CROSSING
 - WATERCOURSE (EPA MAPPED)
 - WATERCOURSE (LOCAL DRAINAGE)

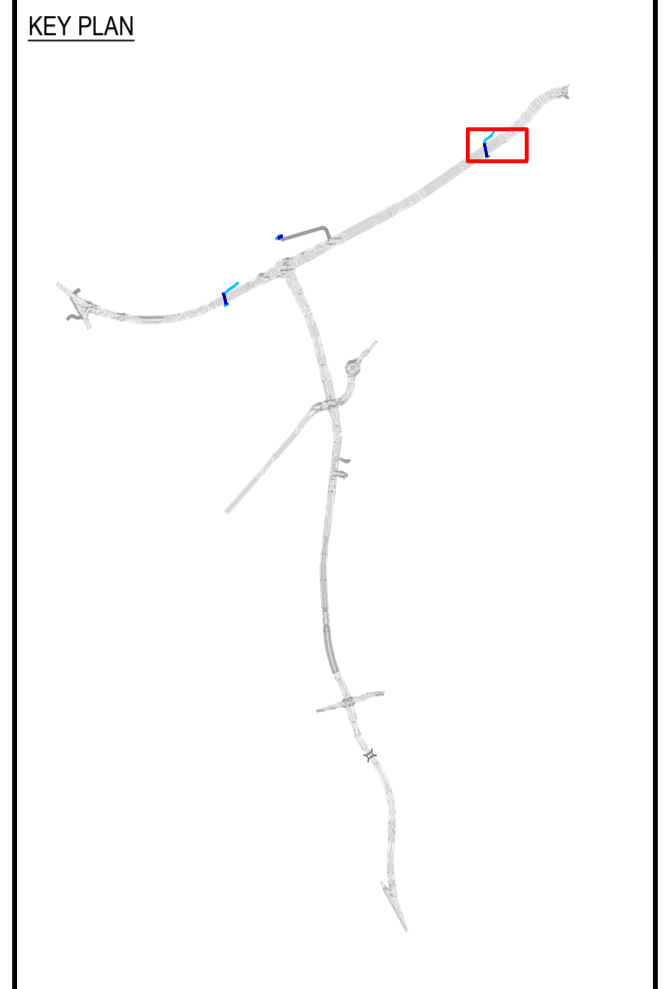

PLAN
1:250

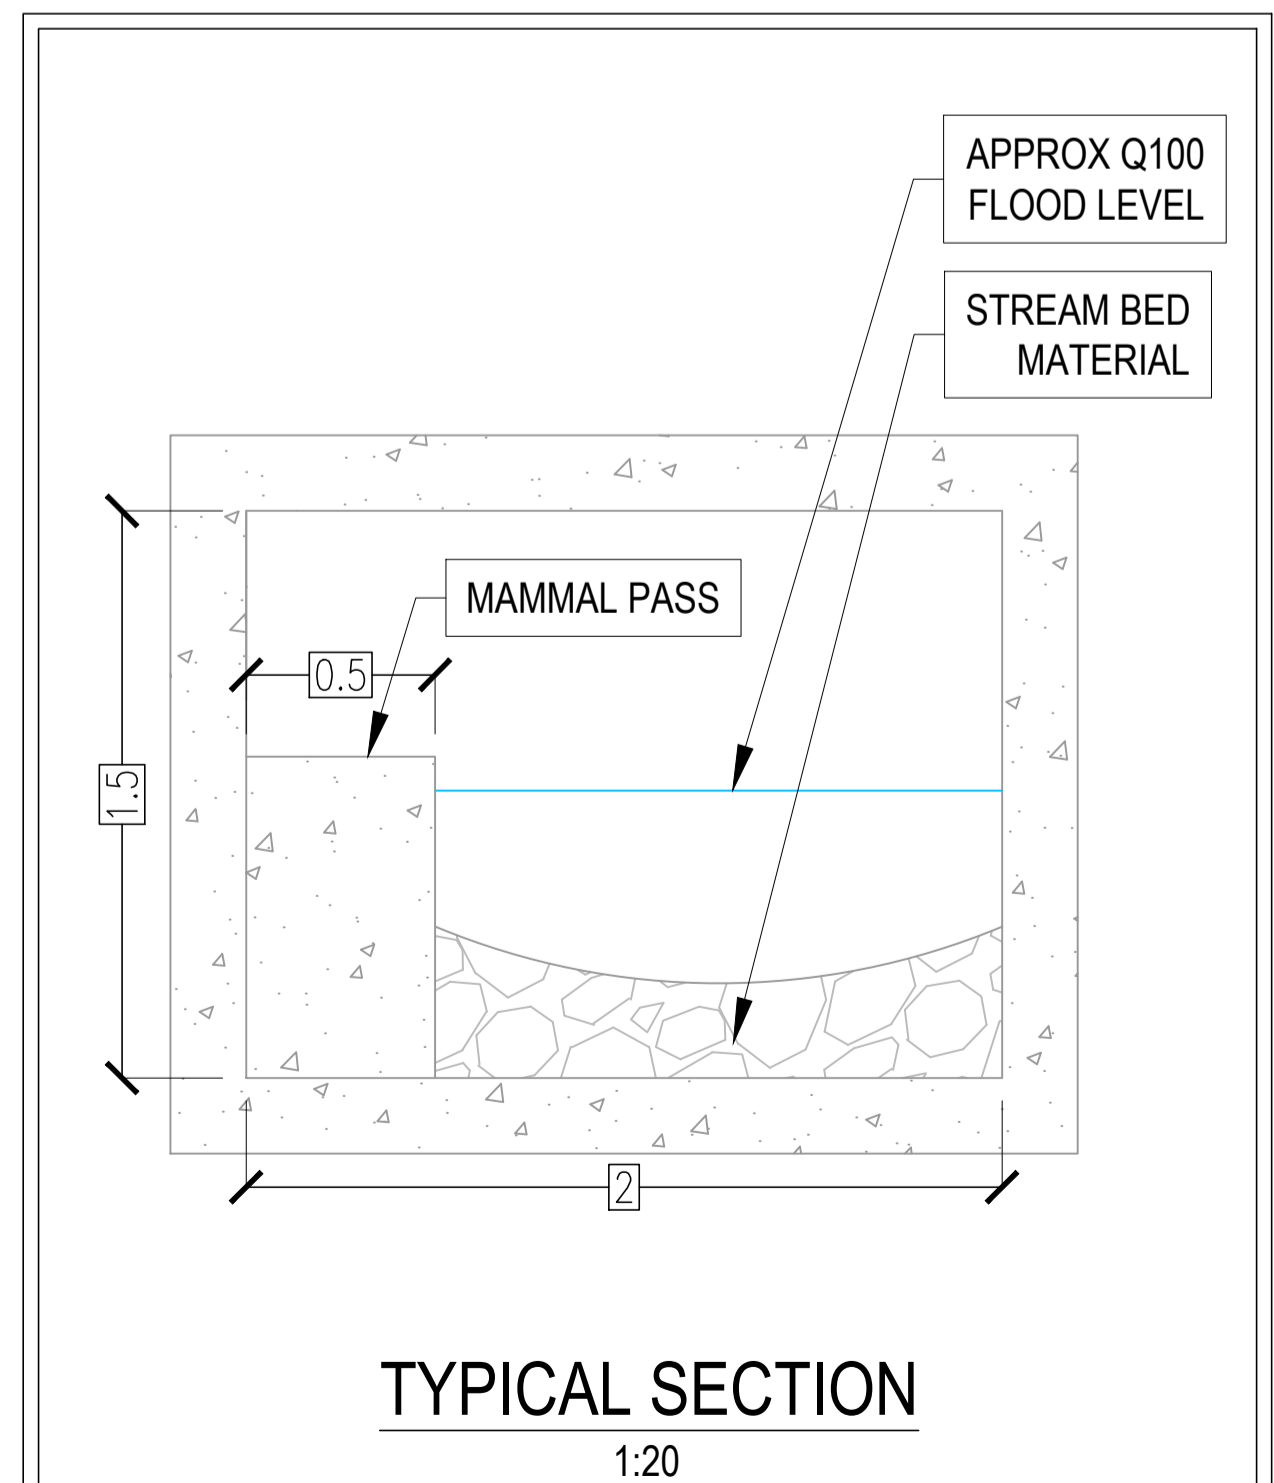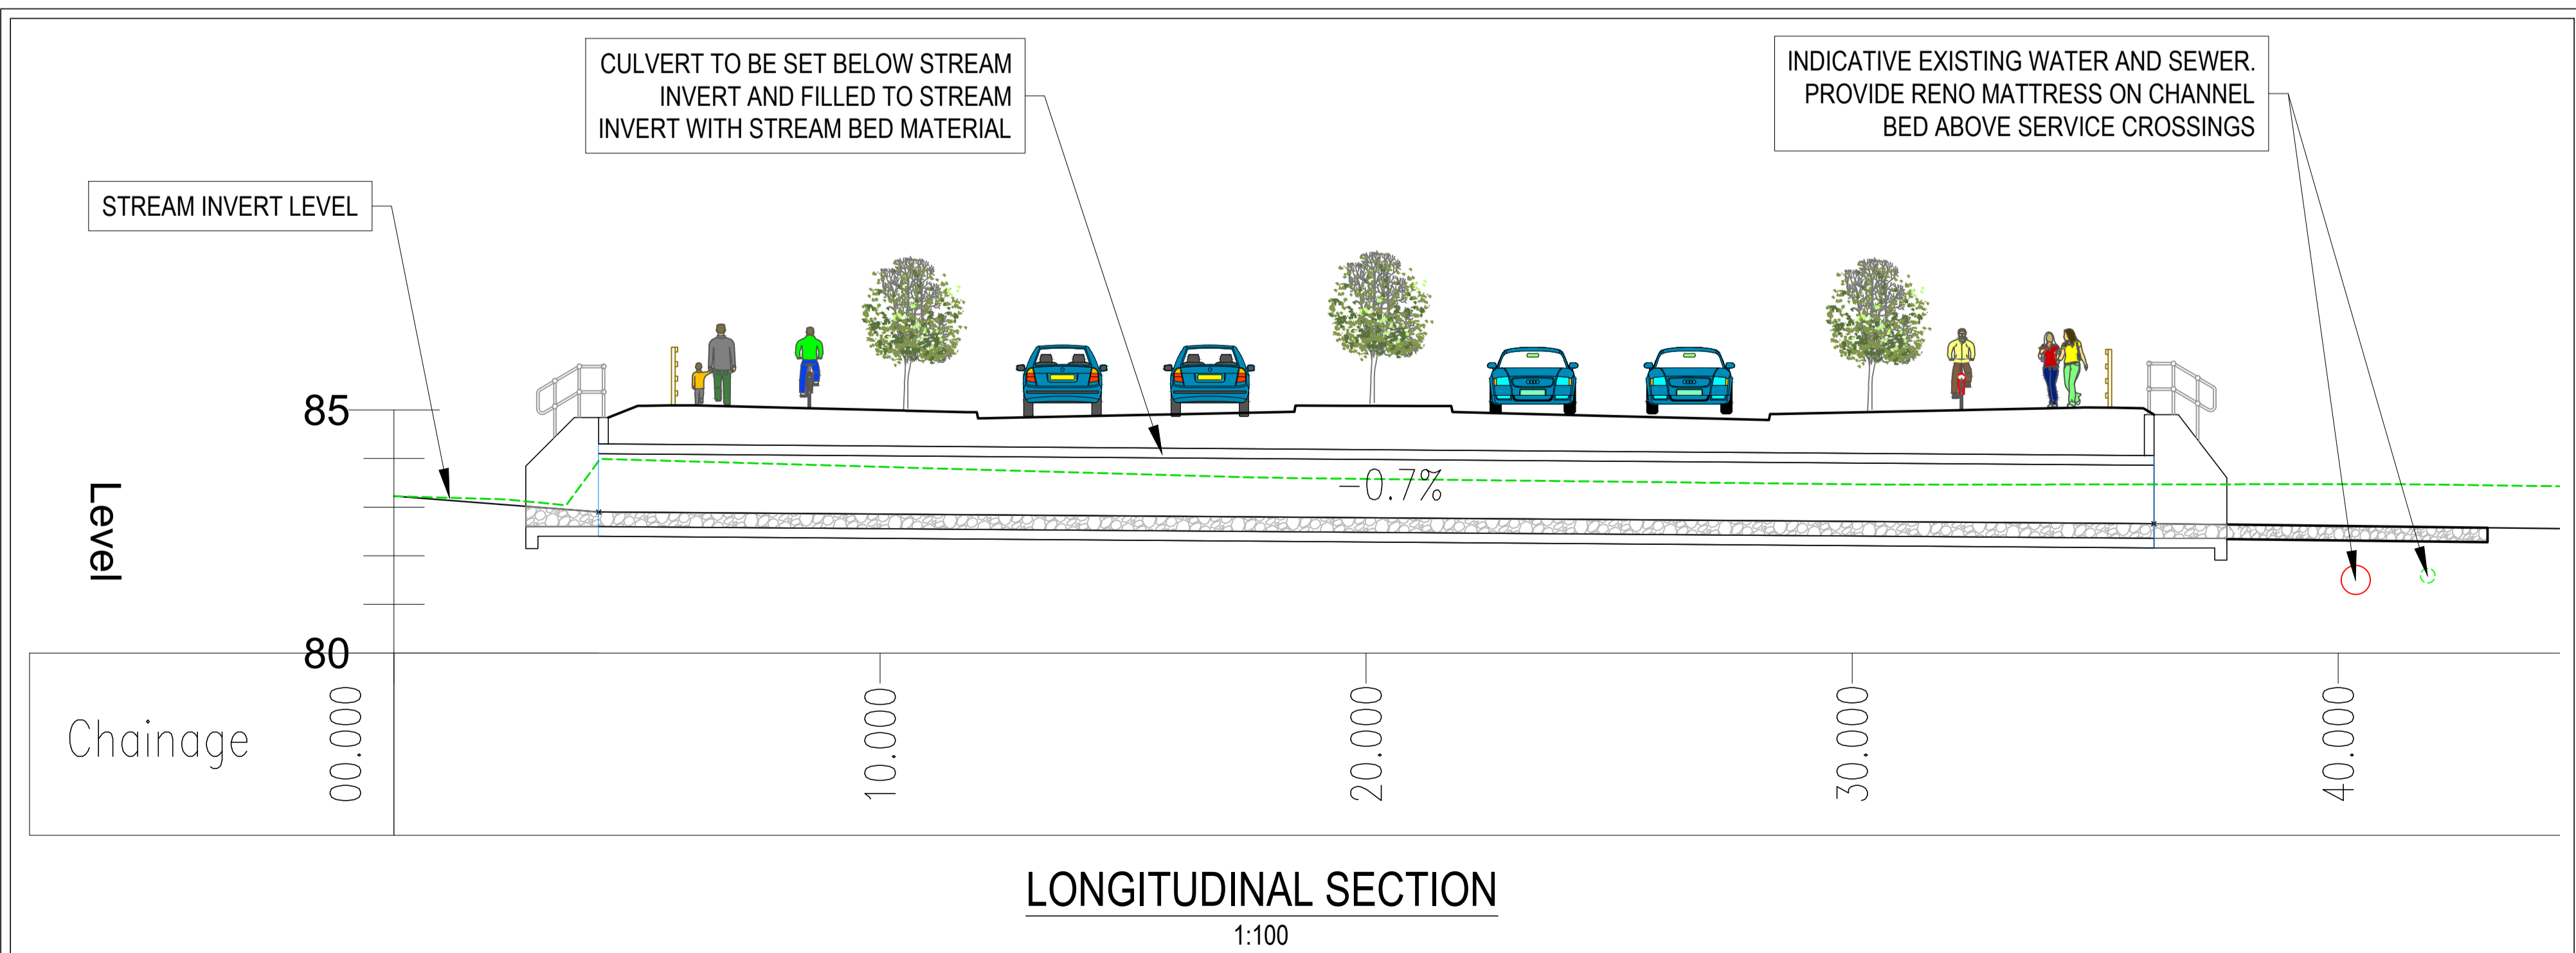

P1	13-03-19	ISSUED FOR PLANNING	DJC	JPC
REV.	DATE	DESCRIPTION	BY	CHKD.
DRAWING SUITABILITY	S2	FOR INFORMATION		
PLANNING				
DESIGNED	JPC	PREPARED	DJC	
DATE	JAN 2019	CHECKED	BLK	

DBFL
 DUBLIN OFFICE Ormond House,
 Upper Ormond Quay, Dublin 7, Ireland.
 PHONE +353 1 400 4000
 FAX +353 1 400 4050
 WATERFORD OFFICE Unit 2, The Chandlers,
 1-2 O'Connell Street, Waterford, Ireland.
 PHONE +353 51 309 500
 FAX +353 51 844 913
 DBFL Consulting Engineers email: info@dbfl.ie site: www.dbfl.ie


PROJECT
GLENAMUCK DISTRICT ROADS SCHEME

DRG. TITLE
FIGURE 14-4 - WATERCROSSING DETAILS - WX03




SCALE AS SHOWN @A1 FILE REF. 170172-DBFL-01-XX-DR-C-3101
 AS SHOWN X2 @A3

DBFL DRG. NO. 170172-DBFL-01-XX-DR-C-3103 P1
 EIA/AR FIGURE REF. FIGURE 14-4

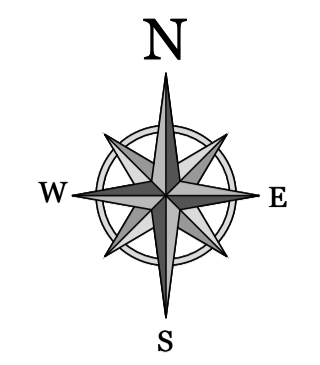




© COPYRIGHT OF THIS DRAWING IS RESERVED BY DBFL CONSULTING ENGINEERS. NO PART SHALL BE REPRODUCED OR TRANSMITTED WITHOUT THEIR WRITTEN PERMISSION.

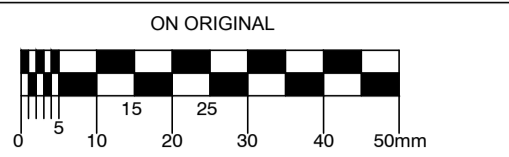

- NOTES:
- DRAWINGS ARE PRELIMINARY DESIGNS FOR PLANNING ONLY AND ARE SUBJECT TO DETAILED DESIGN
 - ALL WATERCOURSE CROSSING WORKS SUBJECT TO OPW SECTION 50 APPROVAL AND APPROVAL BY INLAND FISHERIES IRELAND

LEGEND

WX00	WATERCOURSE CROSSING
	WATERCOURSE (EPA MAPPED)
	WATERCOURSE (LOCAL DRAINAGE)

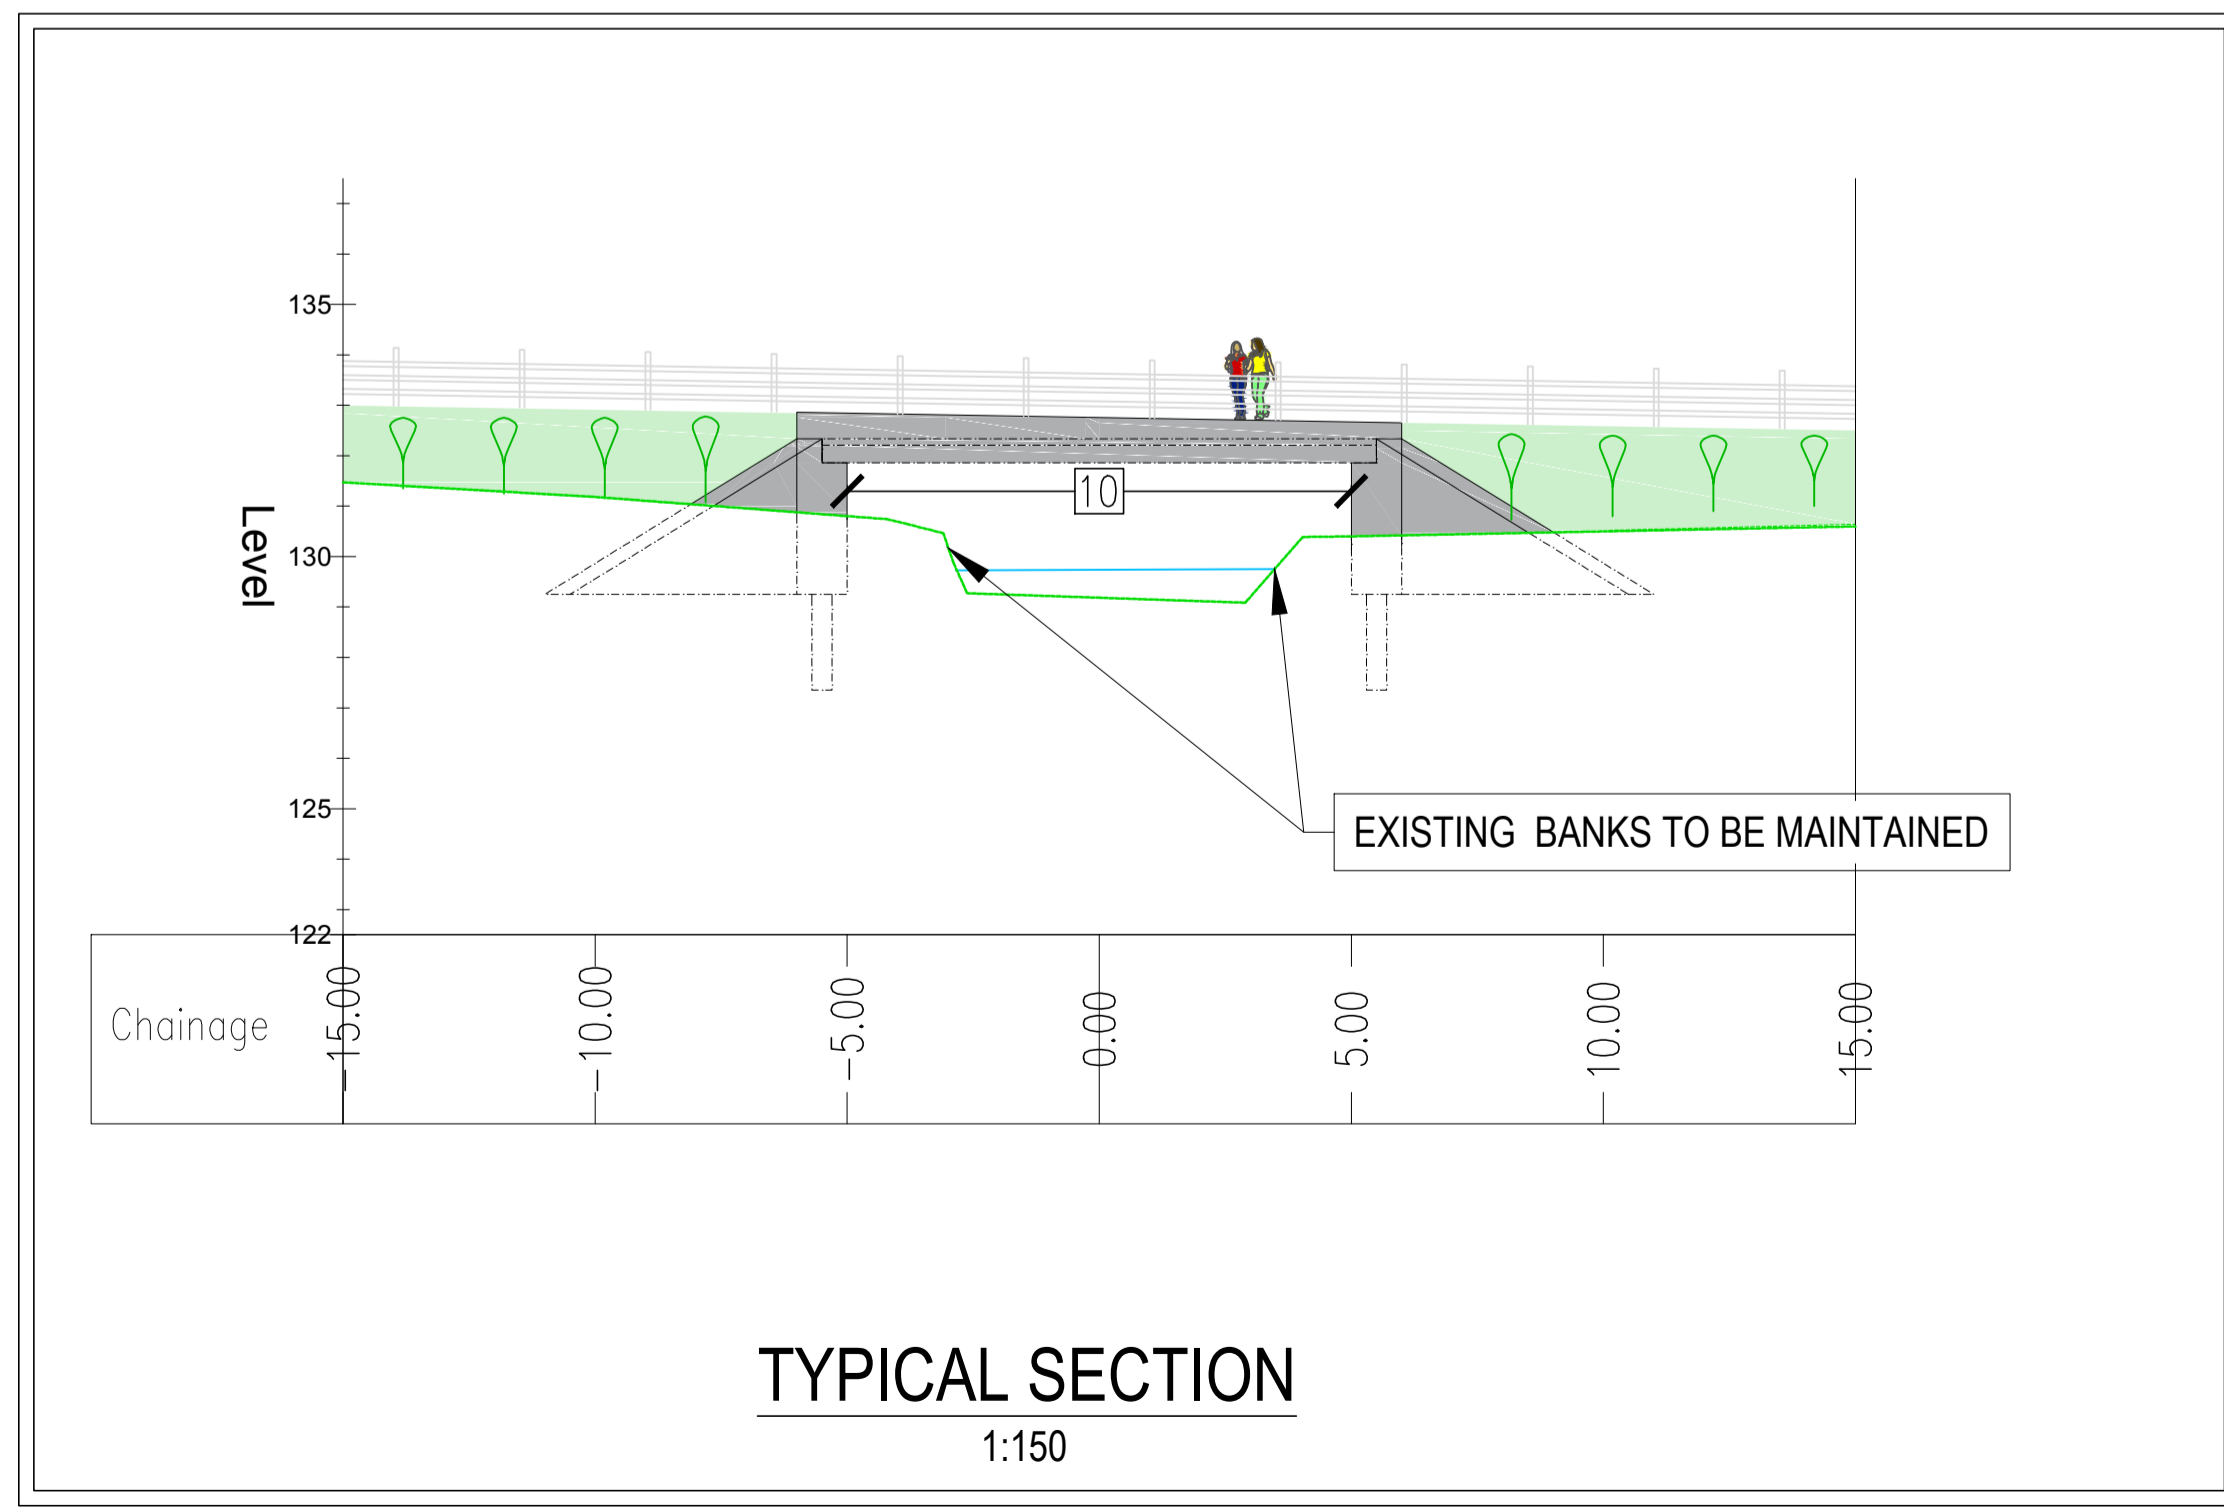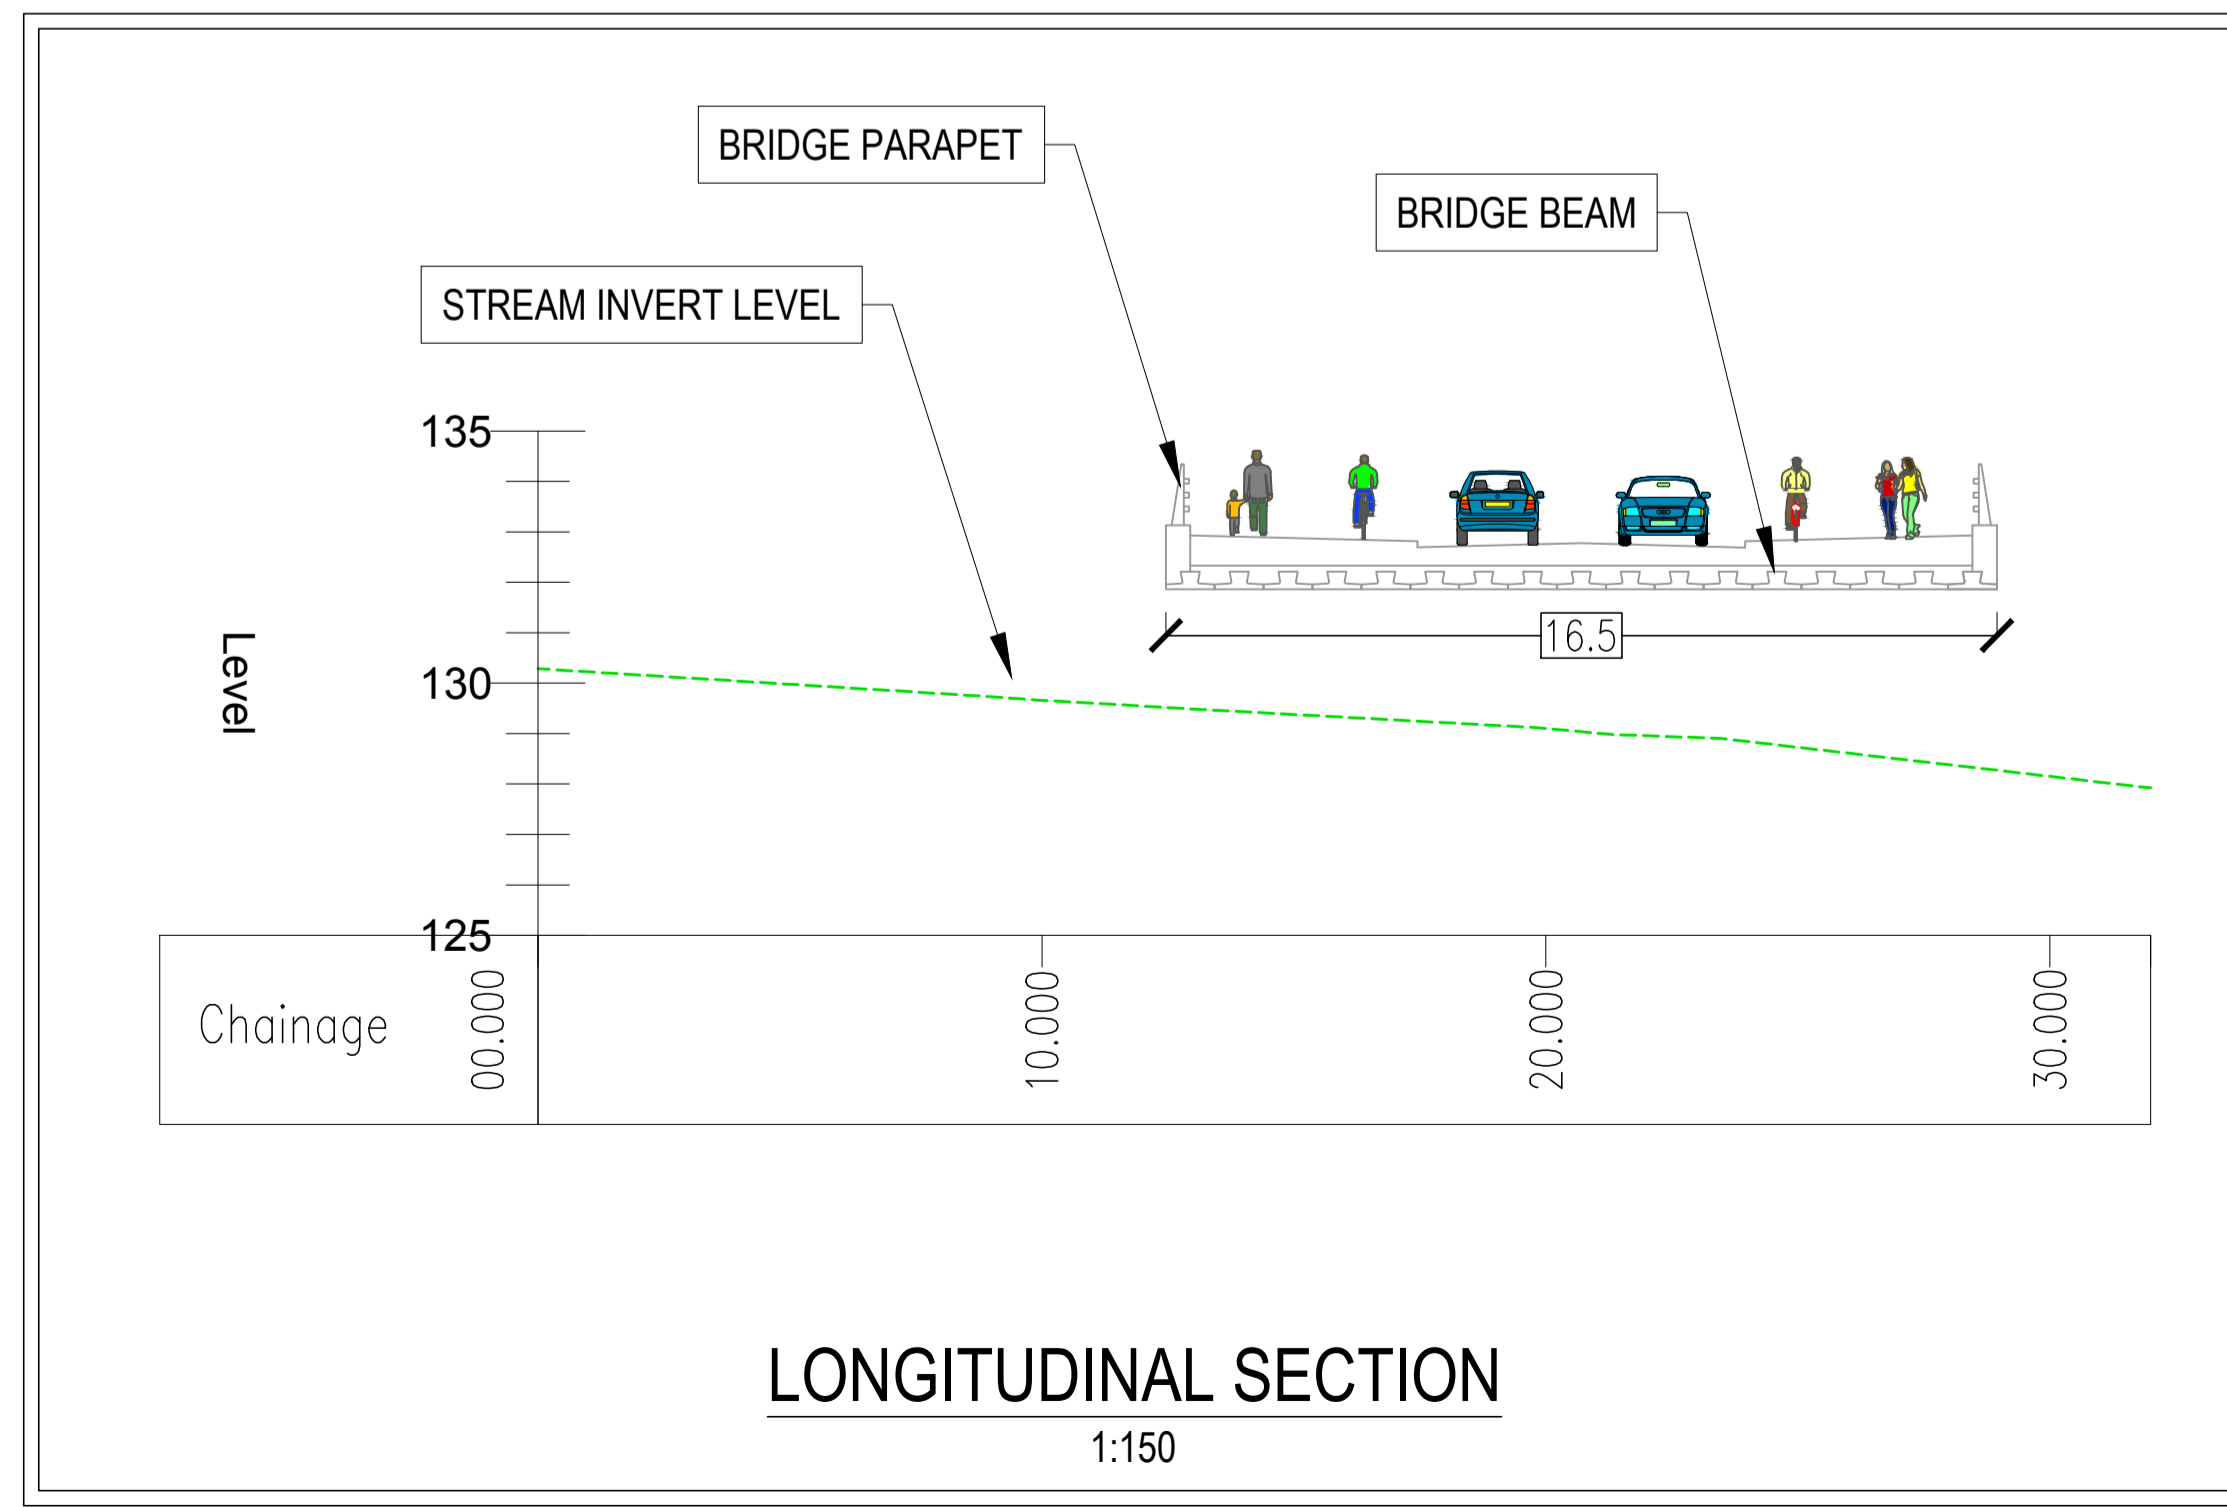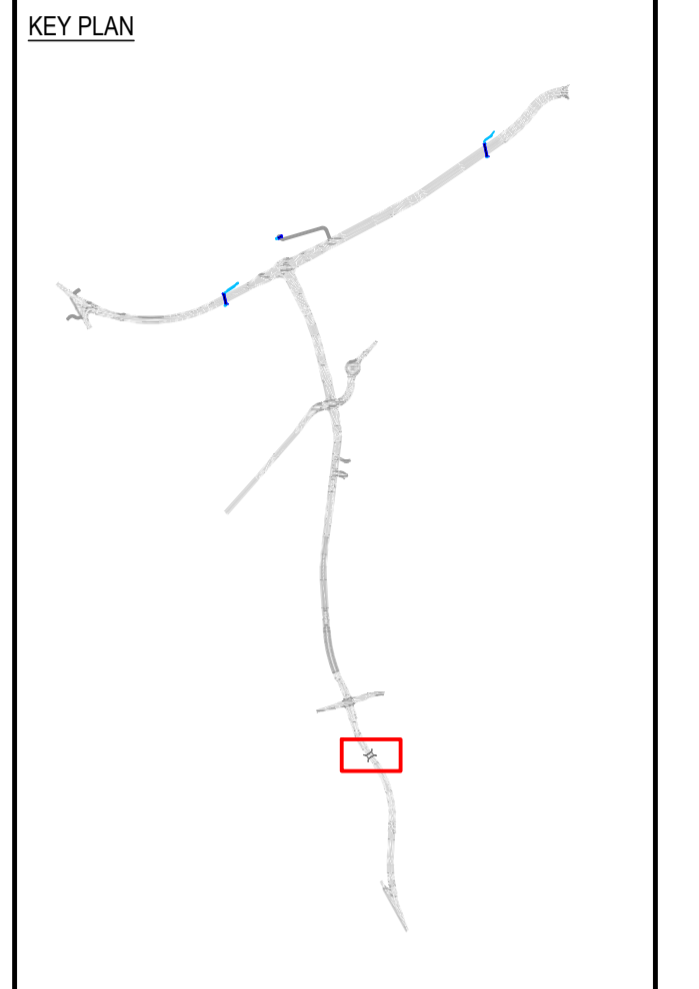

P1	13-03-19	ISSUED FOR PLANNING	DJC	JPC
REV.	DATE	DESCRIPTION	BY	CHKD
DRAWING SUITABILITY		S2 - FOR INFORMATION		
PLANNING				
DESIGNED	JPC	PREPARED	DJC	
DATE	JAN 2019	CHECKED	BLJK	
DUBLIN OFFICE: Ormond House, Upper Ormond Quay, Dublin 7, Ireland. PHONE: +353 1 400 4000 FAX: +353 1 400 4050 WATERFORD OFFICE: Unit 2, The Chandlery, 1-2 O'Connell Street, Waterford, Ireland. PHONE: +353 51 309 500 FAX: +353 51 844 913				
DBFL Consulting Engineers email: info@dbfl.ie site: www.dbfl.ie				

PROJECT
GLENAMUCK DISTRICT ROADS SCHEME


DRG. TITLE
FIGURE 14-5 - WATERCROSSING DETAILS - WX04





SCALE AS SHOWN @A1 FILE REF. 170172-DBFL-01-XX-DR-C-3101
AS SHOWN X2 @A3

DBFL DRG. NO. 170172-DBFL-01-XX-DR-C-3104 P1

EIAR FIGURE REF. **FIGURE 14-5**

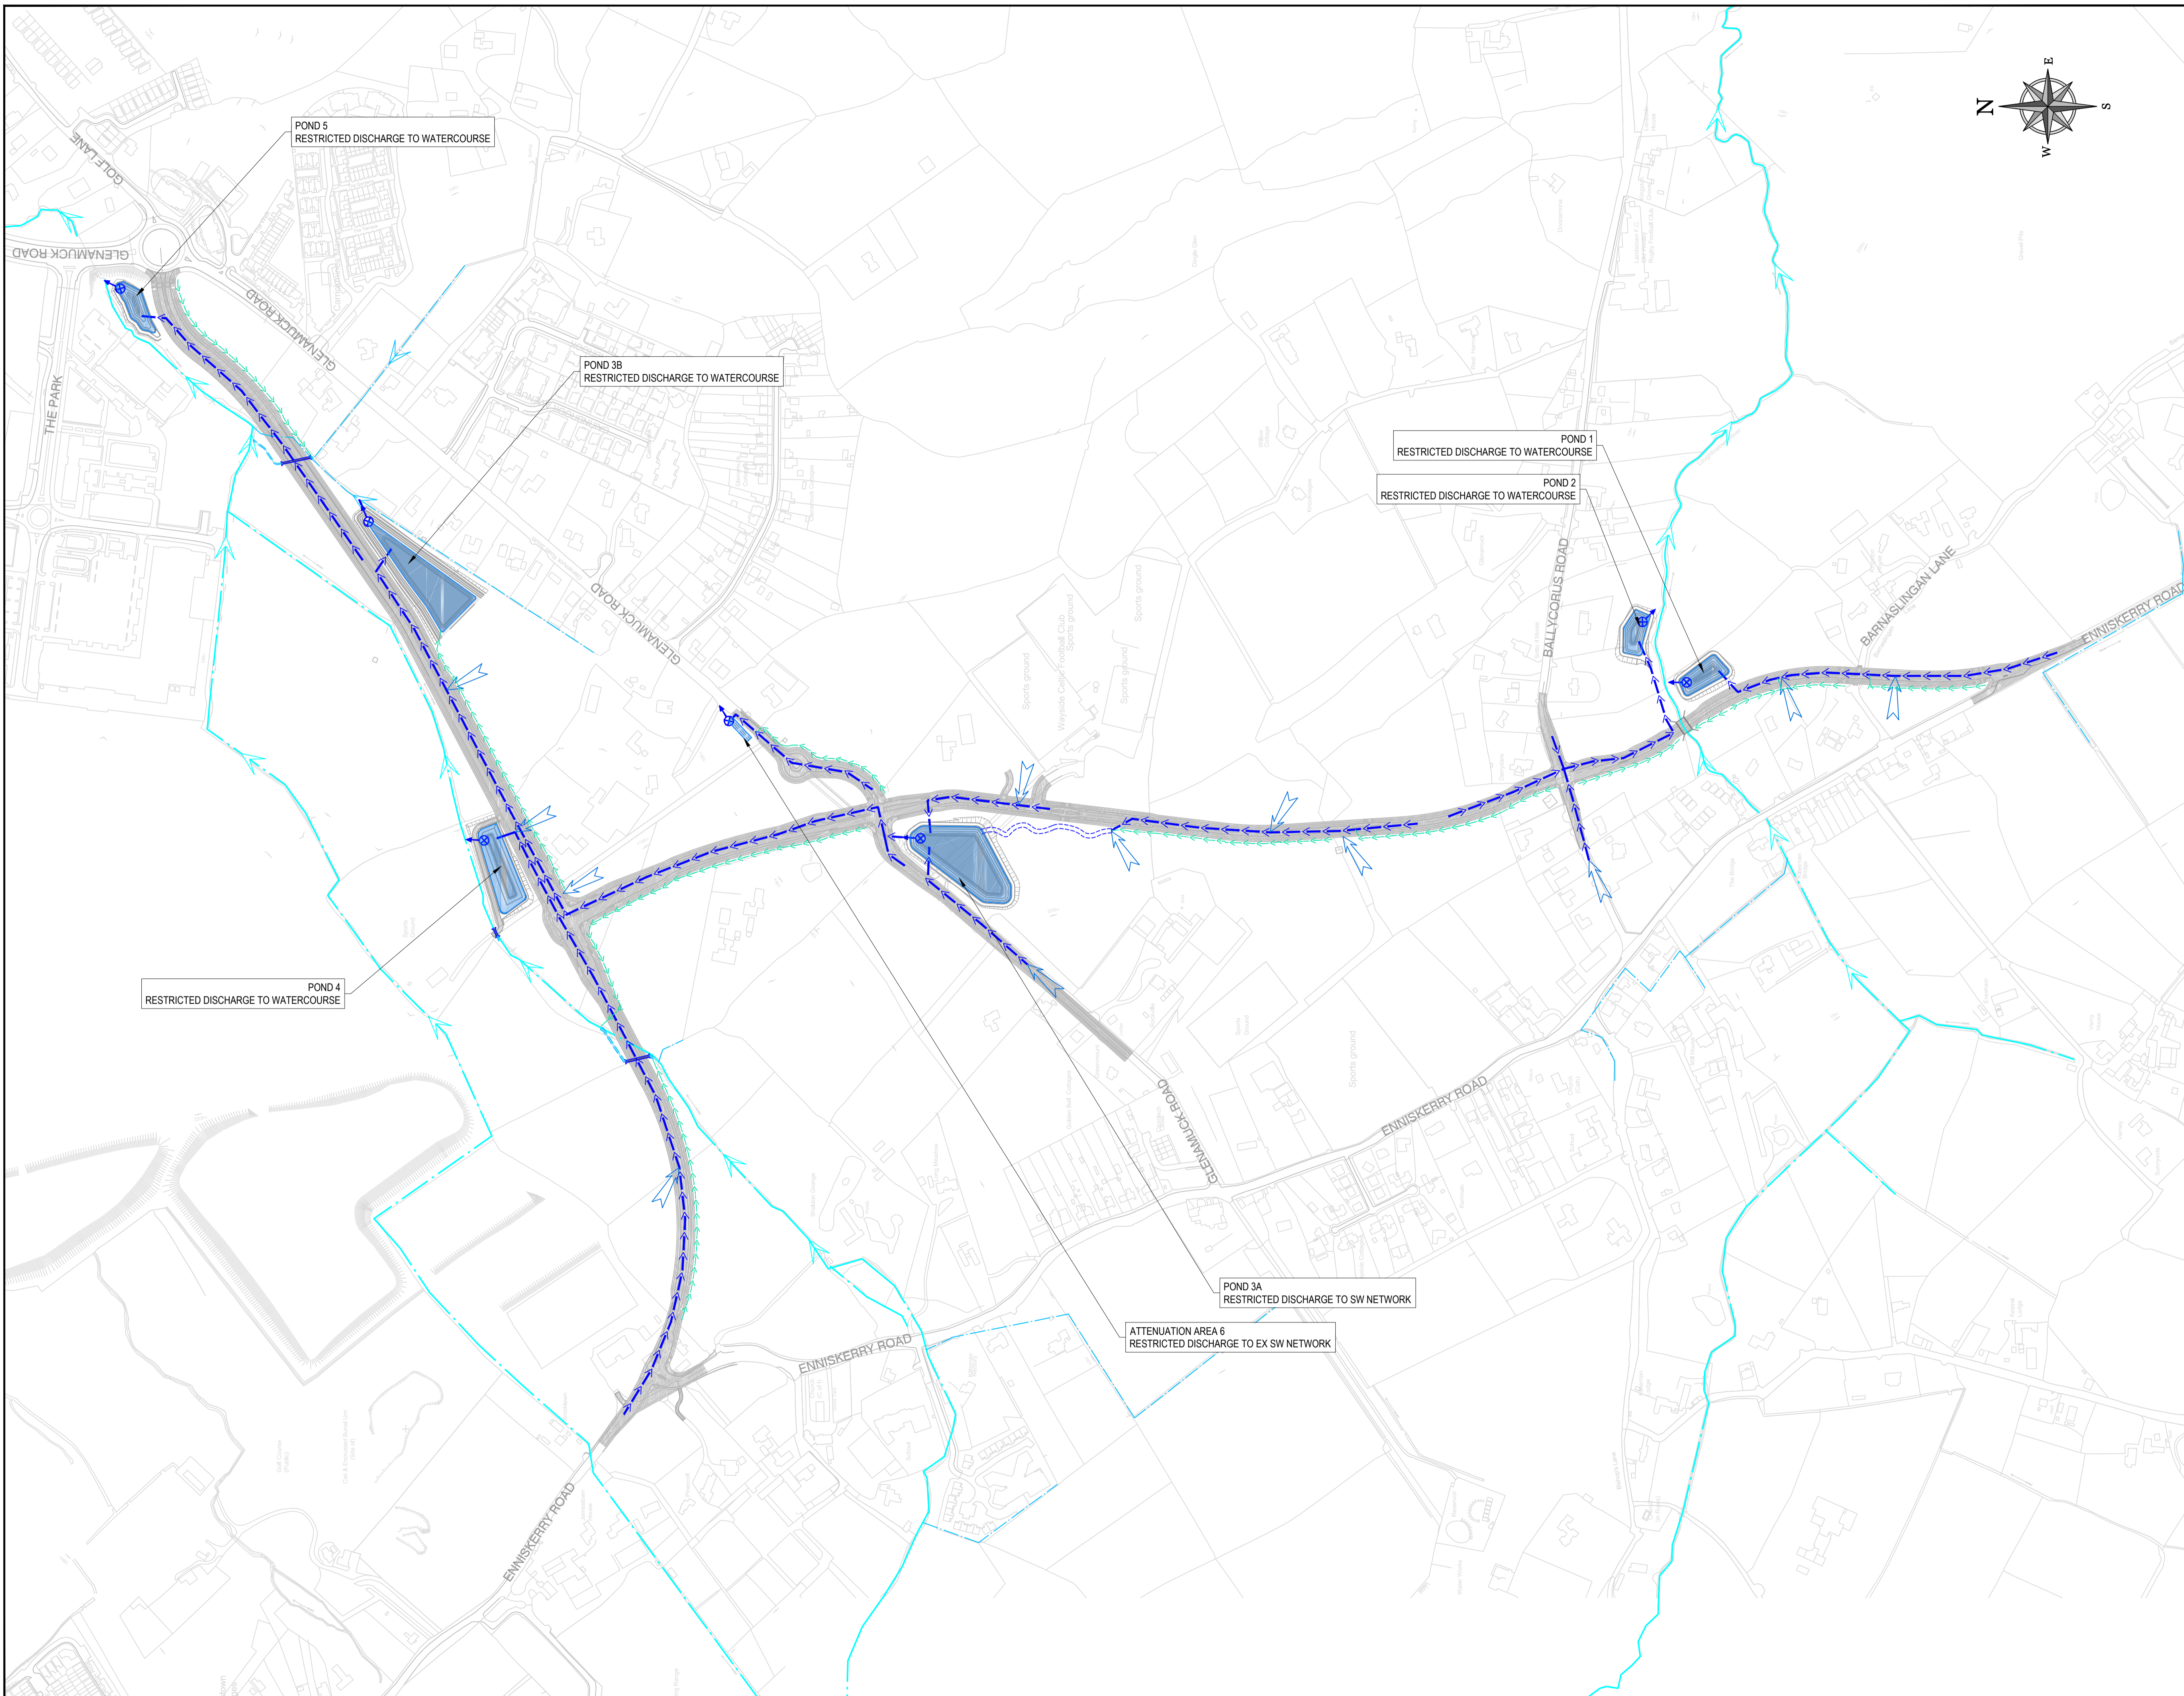

© COPYRIGHT OF THIS DRAWING IS RESERVED BY DBFL CONSULTING ENGINEERS. NO PART SHALL BE REPRODUCED OR TRANSMITTED WITHOUT THEIR WRITTEN PERMISSION.

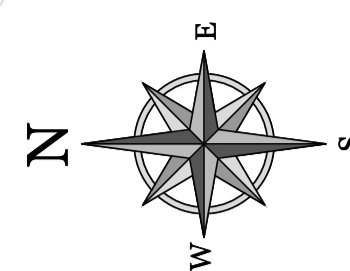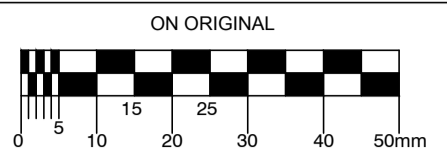

- NOTES:
1. DRAWINGS ARE PRELIMINARY DESIGNS FOR PLANNING ONLY AND ARE SUBJECT TO DETAILED DESIGN
 2. ALL WATERCOURSE CROSSING WORKS SUBJECT TO OPW SECTION 50 APPROVAL AND APPROVAL BY INLAND FISHERIES IRELAND

- LEGEND
- WATERCOURSE (EPA MAPPED)
 - WATERCOURSE (LOCAL DRAINAGE)
 - INDICATIVE PROPOSED DRAINAGE MAIN
 - INDICATIVE PROPOSED INTERCEPTION DRAINAGE
 - INDICATIVE PROPOSED BIOSWALE
 - CONCEPTUAL DEVELOPMENT INFLOWS
 - FLOW RESTRICTED OUTFALL

P1	09-01-19	ISSUED FOR PLANNING	DJC	JPC
REV.	DATE	DESCRIPTION	BY	CHKD
DRAWING SUITABILITY		S2 - FOR INFORMATION		
PLANNING				
DESIGNED	JPC	PREPARED	DJC	
DATE	JAN 2019	CHECKED	BLJK	

DBFL
 DUBLIN OFFICE Ormond House,
 Upper Ormond Quay, Dublin 7, Ireland.
 PHONE +353 1 400 4000
 FAX +353 1 400 4050

WATERFORD OFFICE Unit 2, The Chandlery,
 1-2 O'Connell Street, Waterford, Ireland.
 PHONE +353 51 309 500
 FAX +353 51 844 913

DBFL Consulting Engineers email: info@dbfl.ie www: www.dbfl.ie

PROJECT
GLENAMUCK DISTRICT ROADS SCHEME

DRG. TITLE
FIGURE 14-6 - DRAINAGE LAYOUT

CLIENT

 Comhairle Contae County Council

SCALE 1:3500 @A1
 1:7000 @A3 FILE REF. 170172-DBFL-01-XX-DR-C-3105

DBFL DRG. NO. 170172-DBFL-01-XX-DR-C-3105 P1

EIAR FIGURE REF **FIGURE 14-6**